



1 SET PLAN
SCALE: 1/2" = 1'-0"

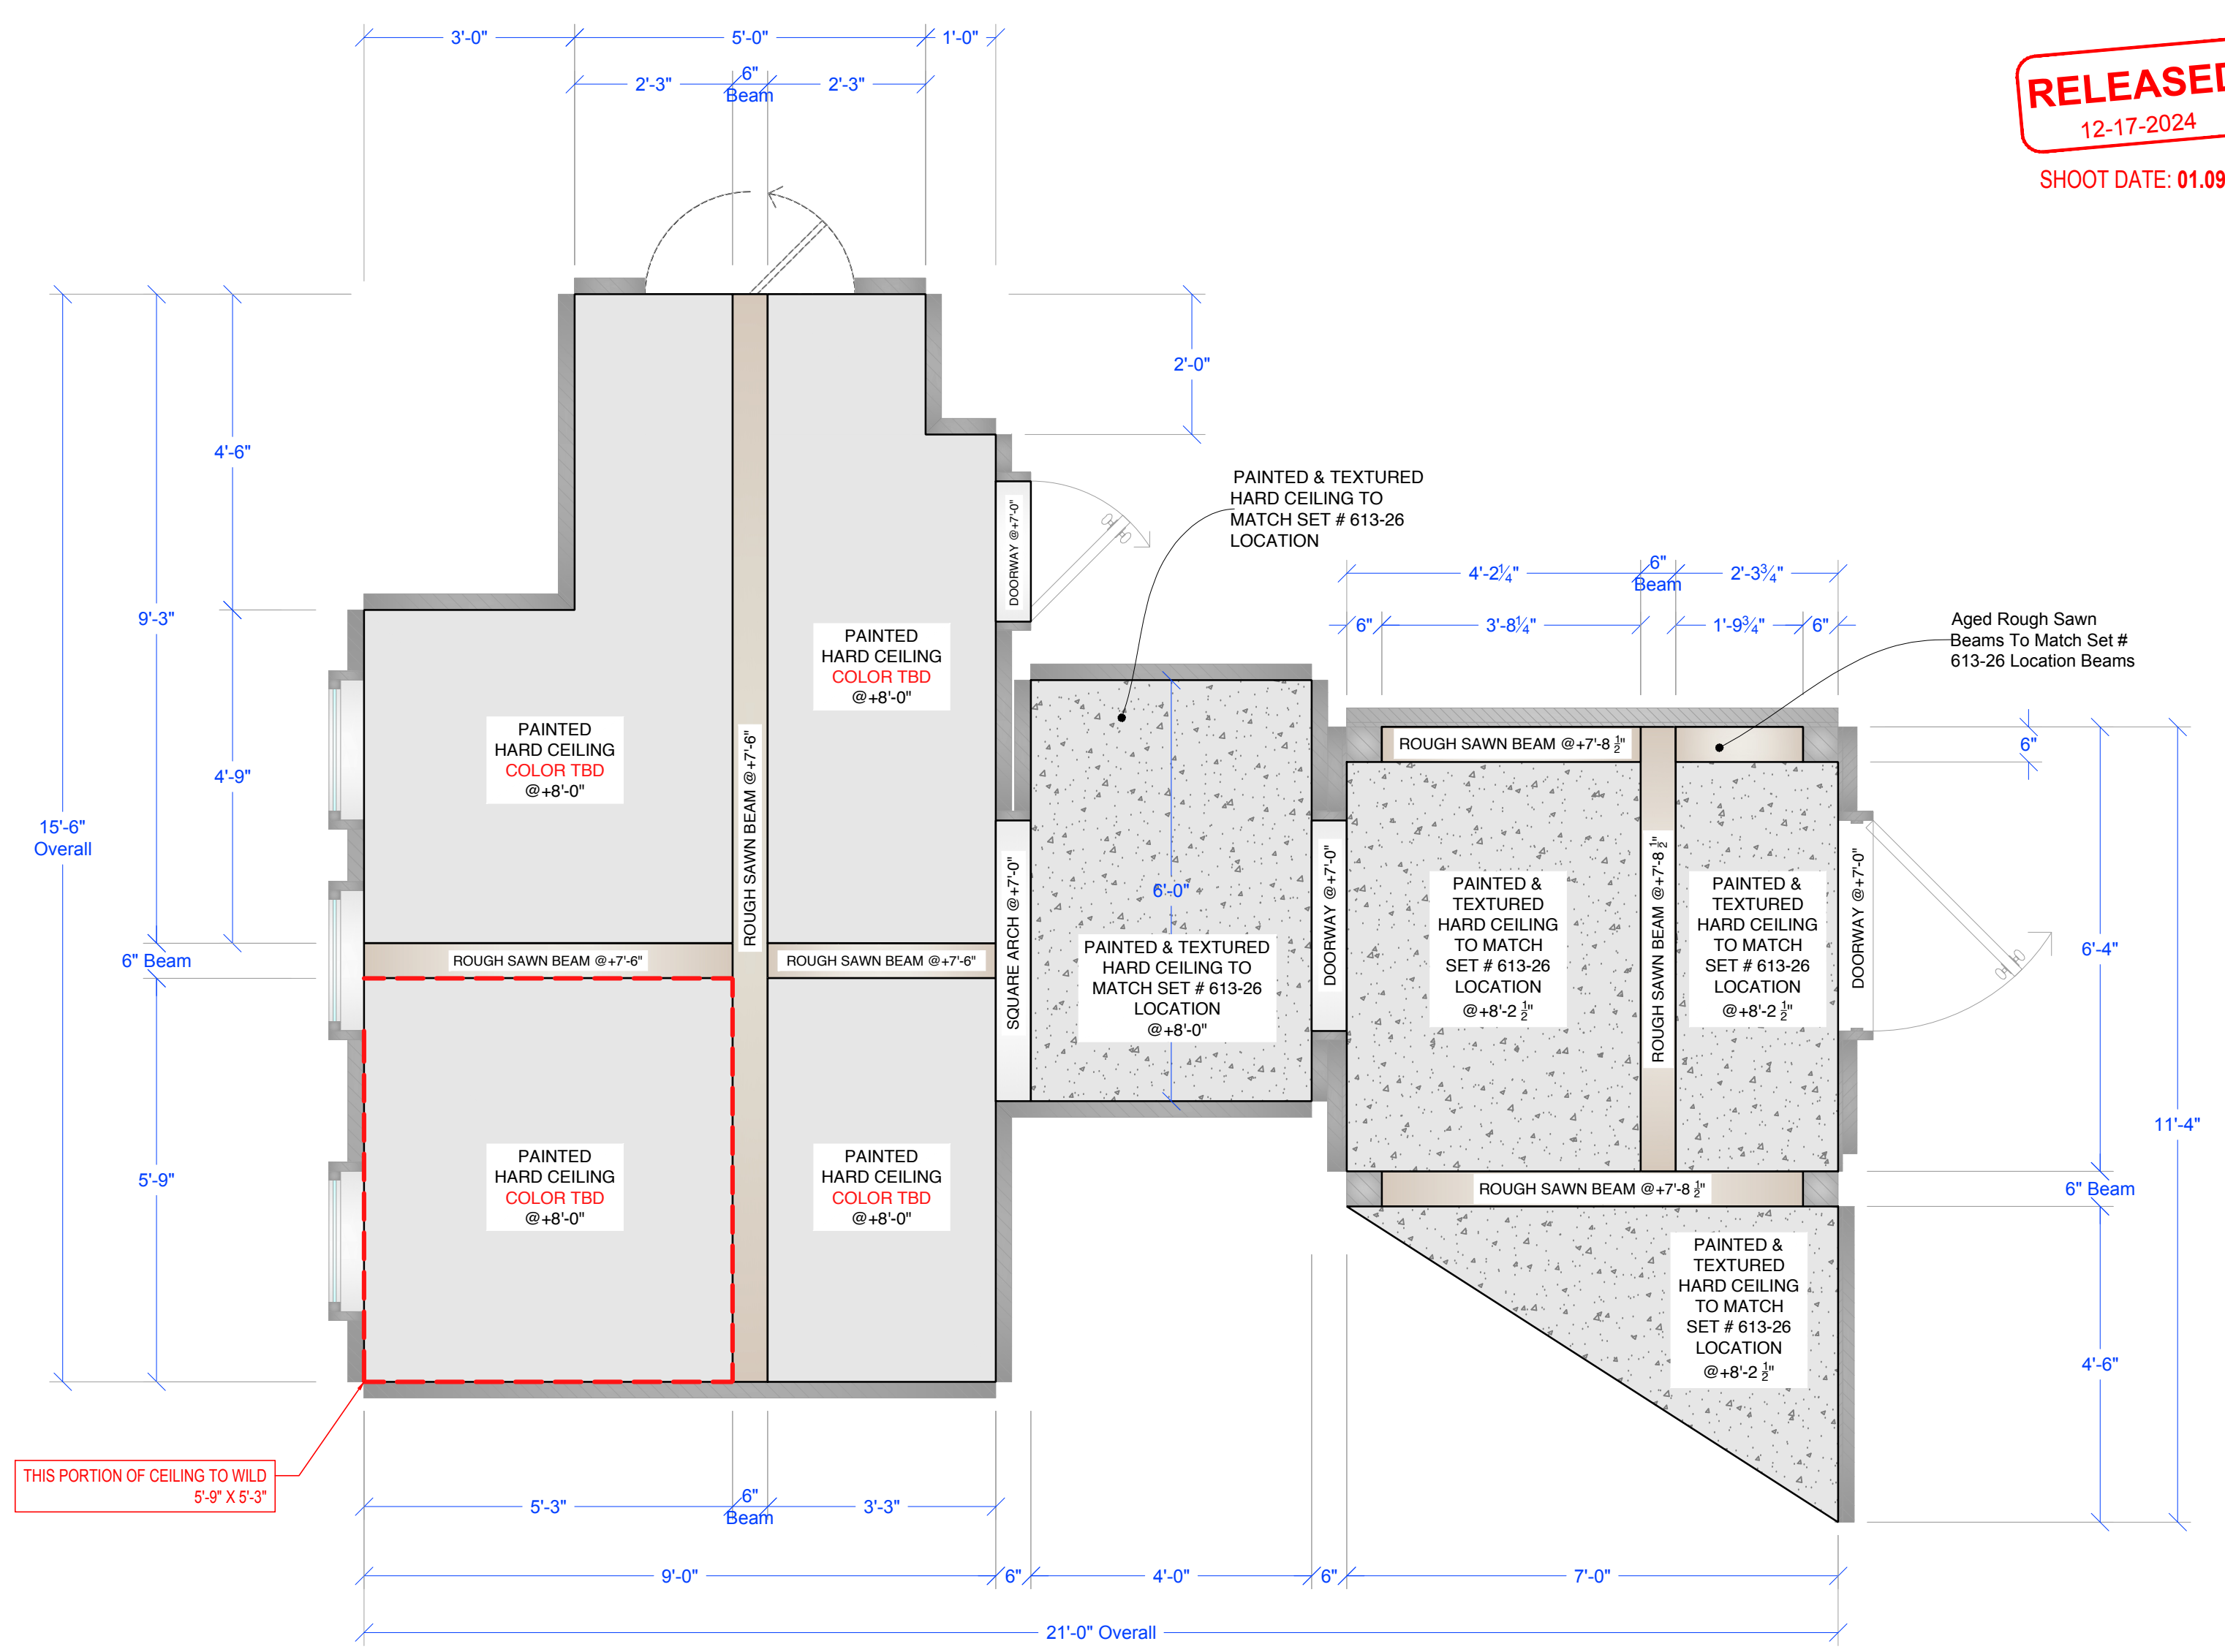

2 REFLECTED CEILING PLAN
SCALE: 1/2" = 1'-0"









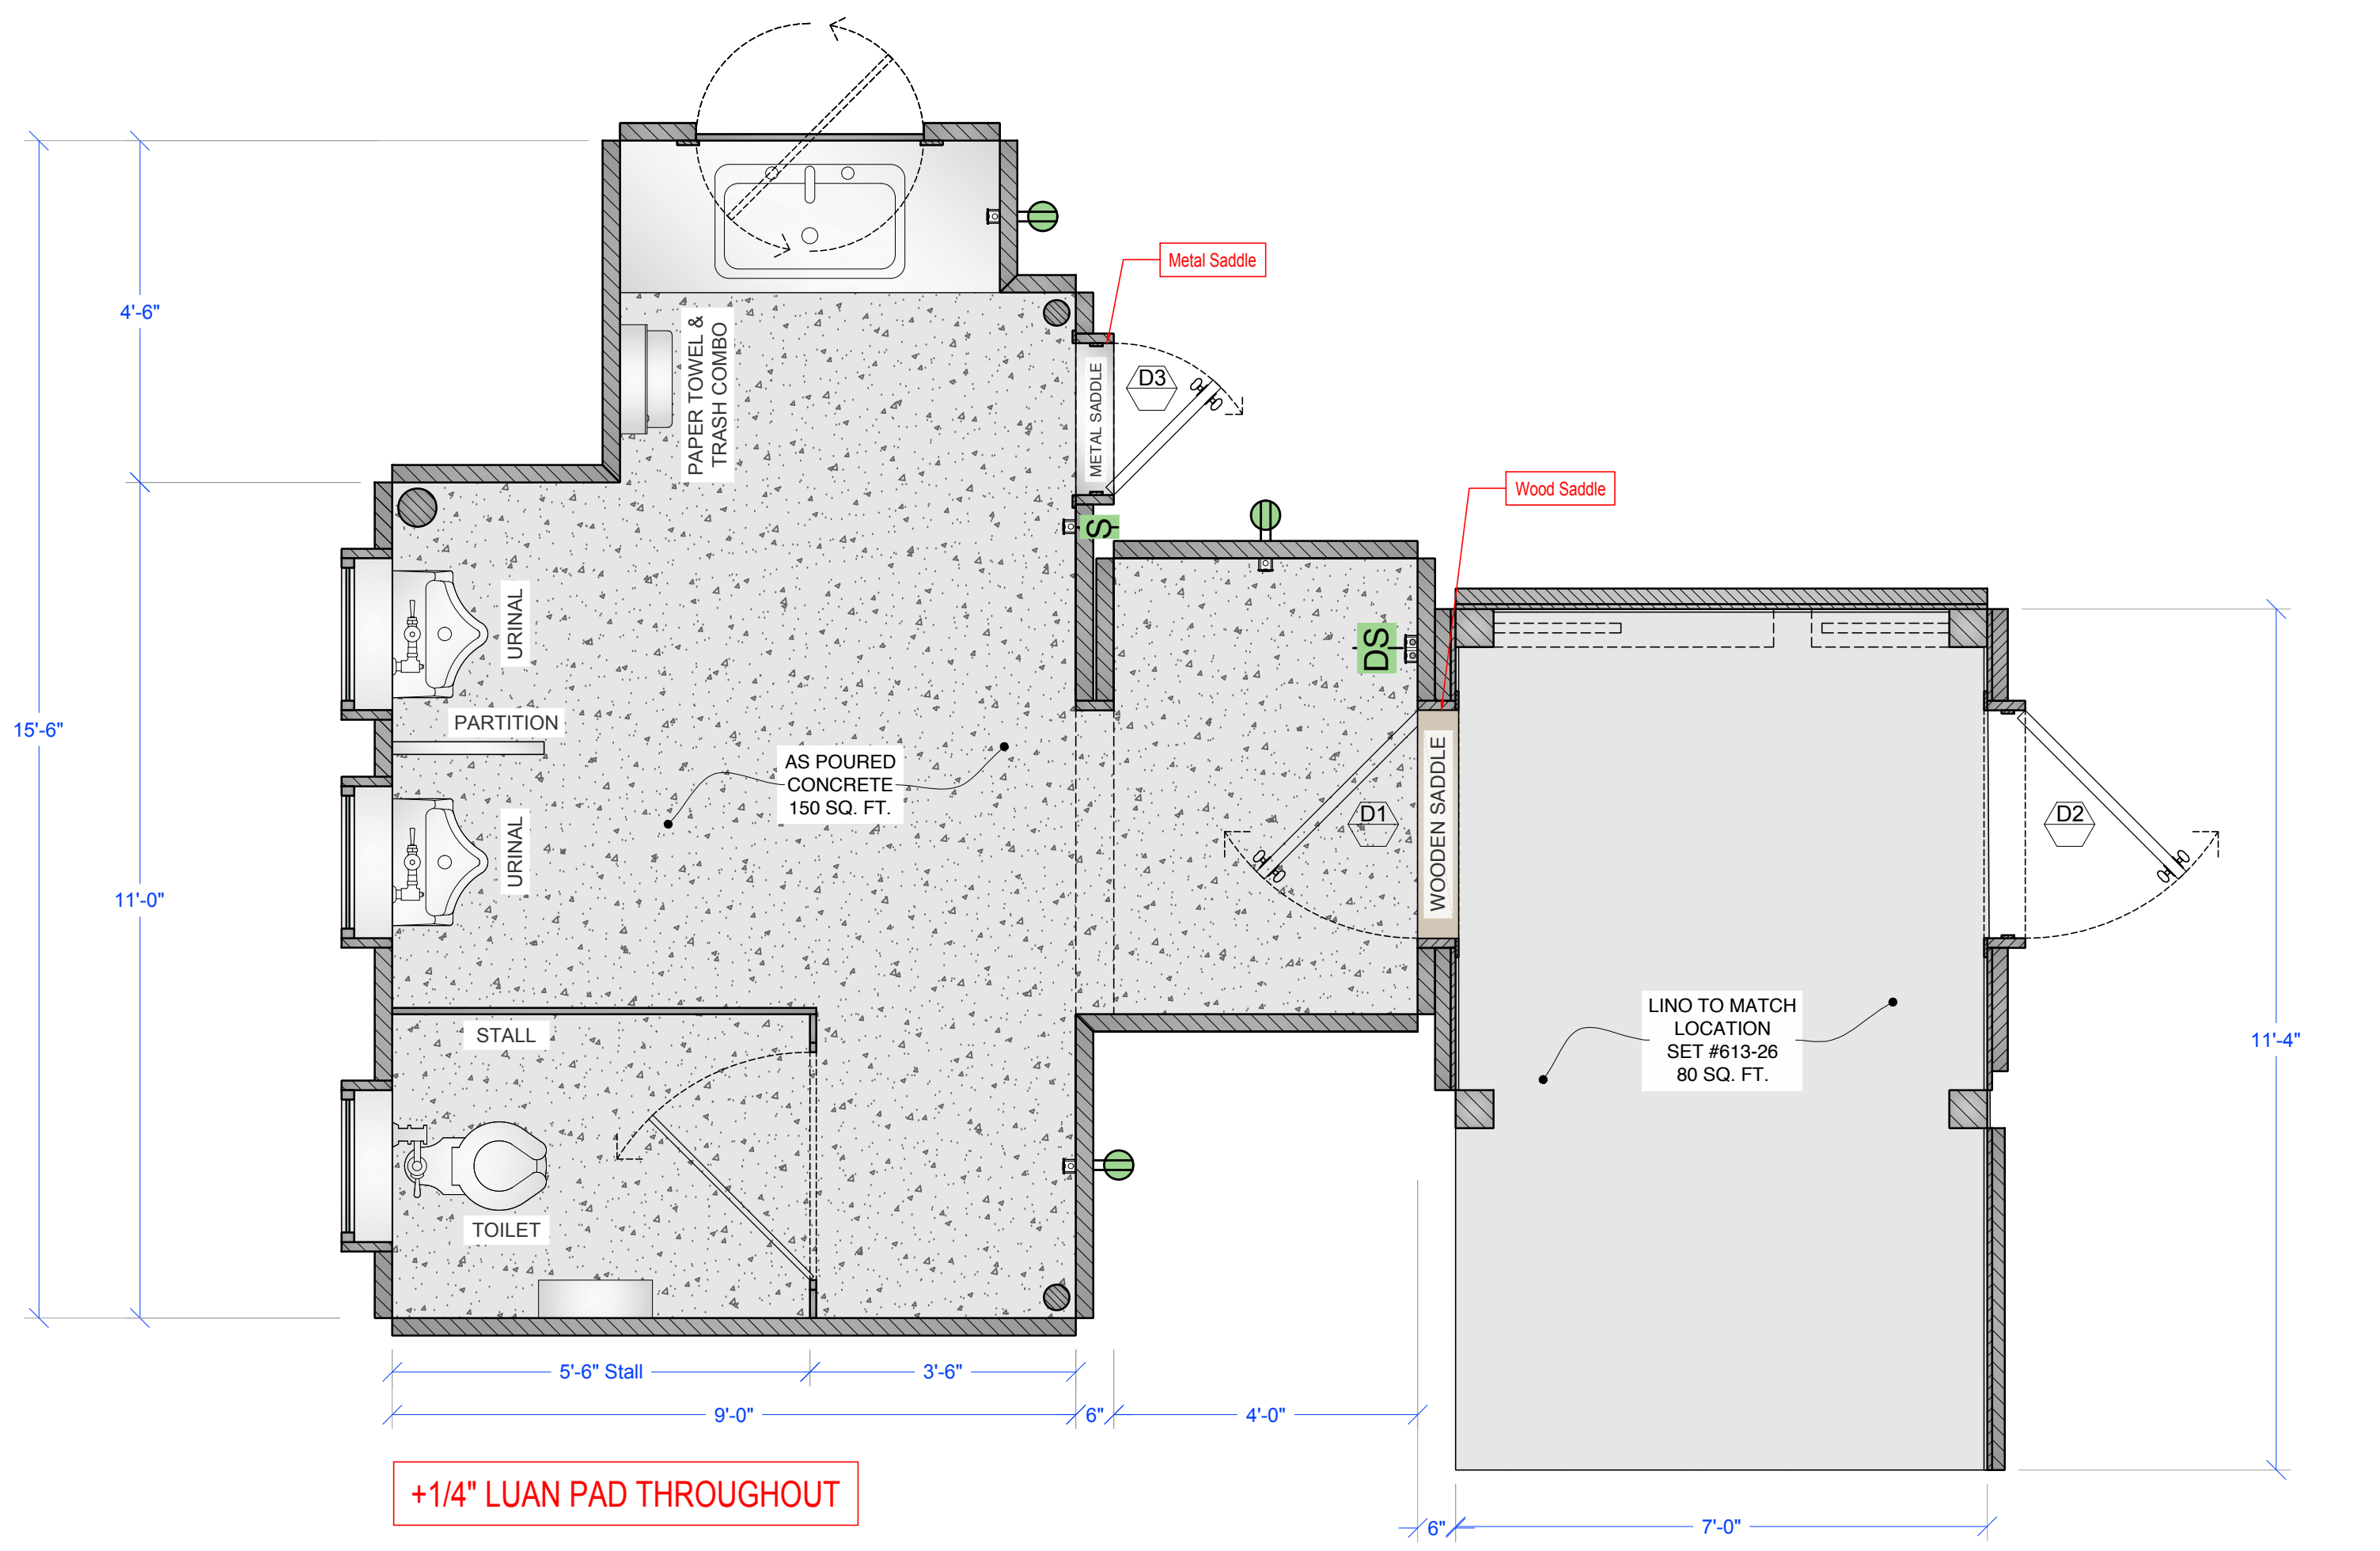


3 FLOORING PLAN
SCALE: 1/2" = 1'-0"



CEILING REFERENCE PHOTO
SCALE: NOT TO SCALE

+1/4" LUAN PAD THROUGHOUT

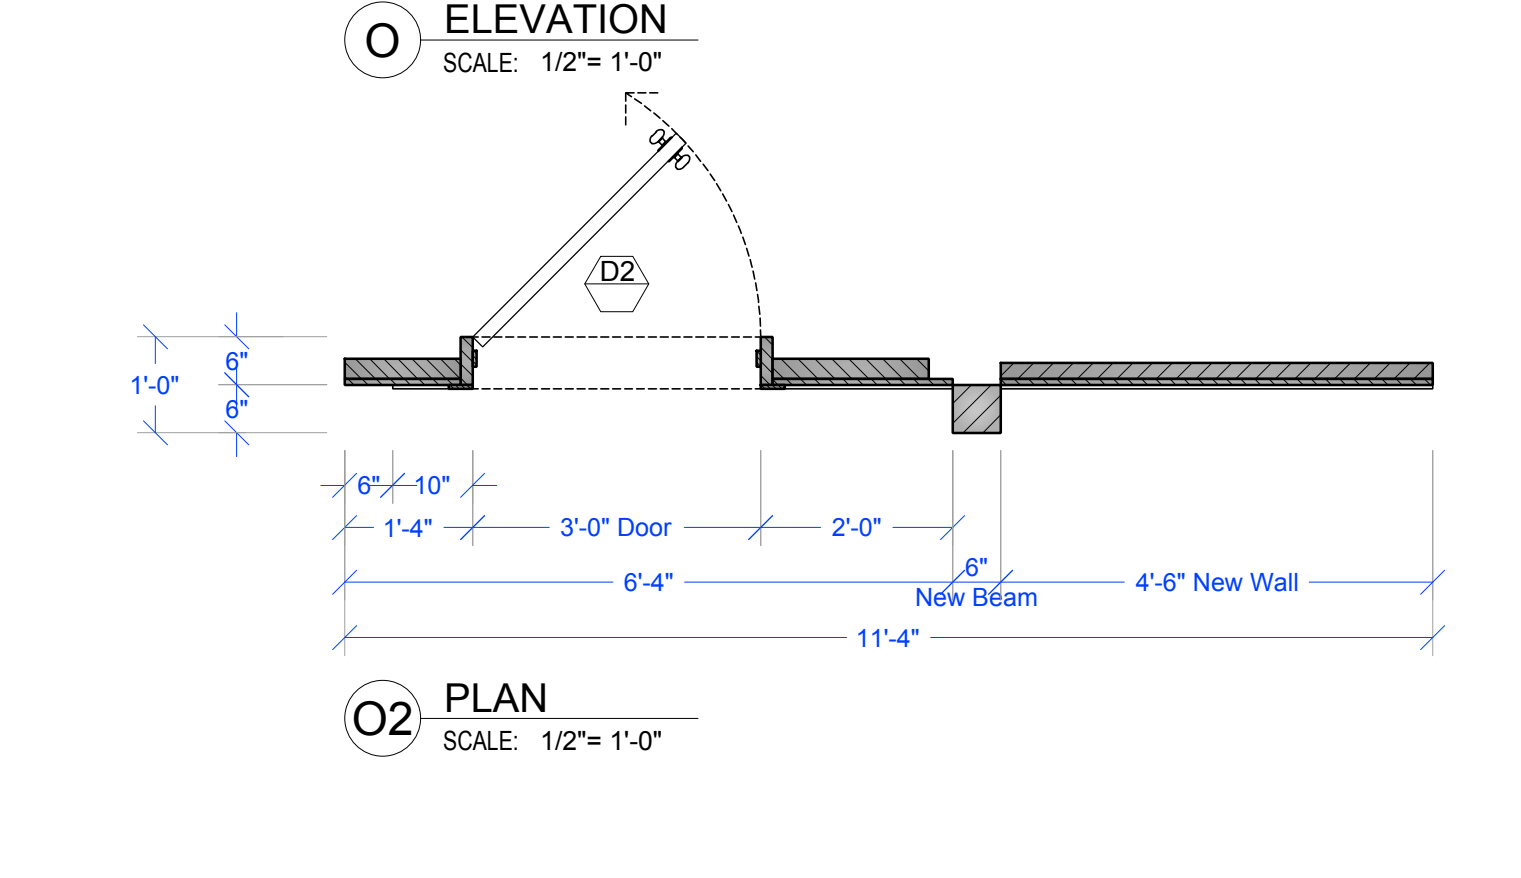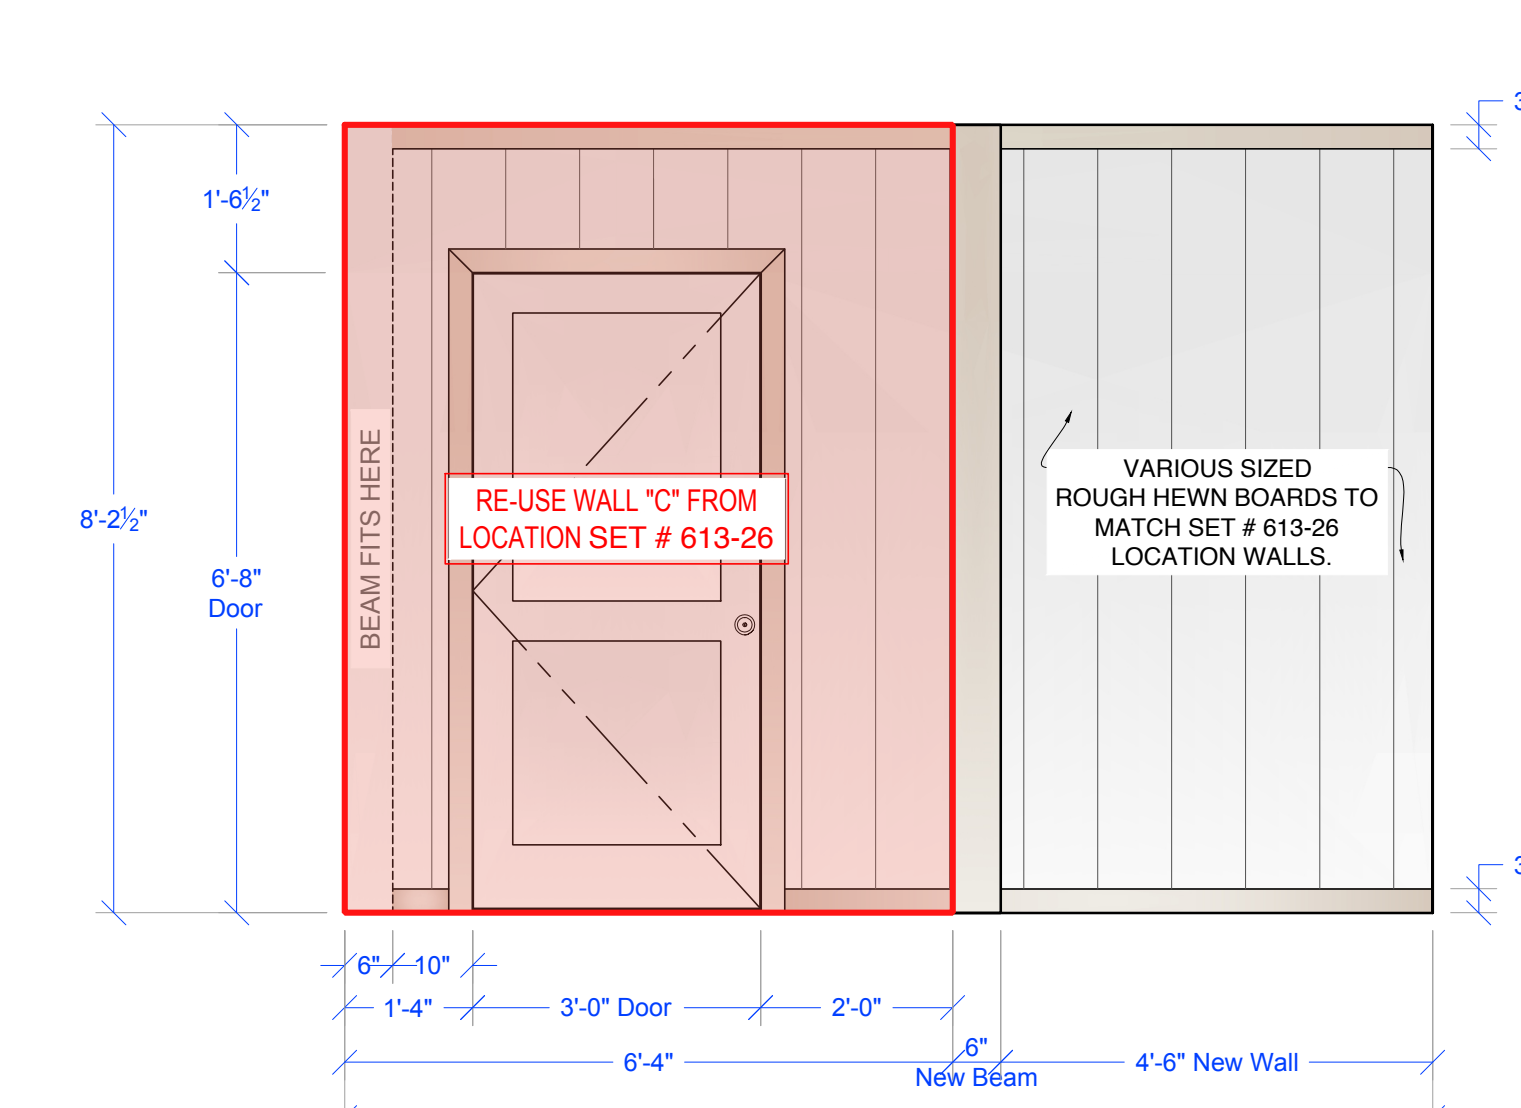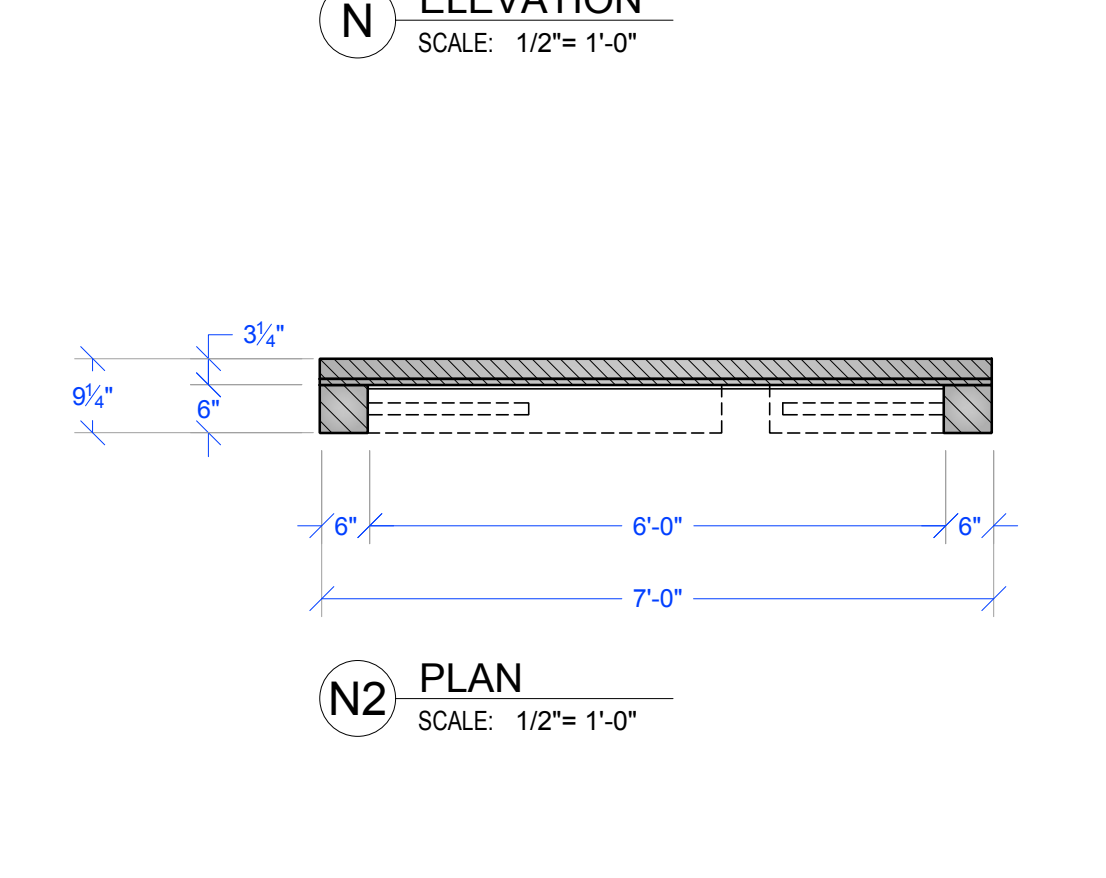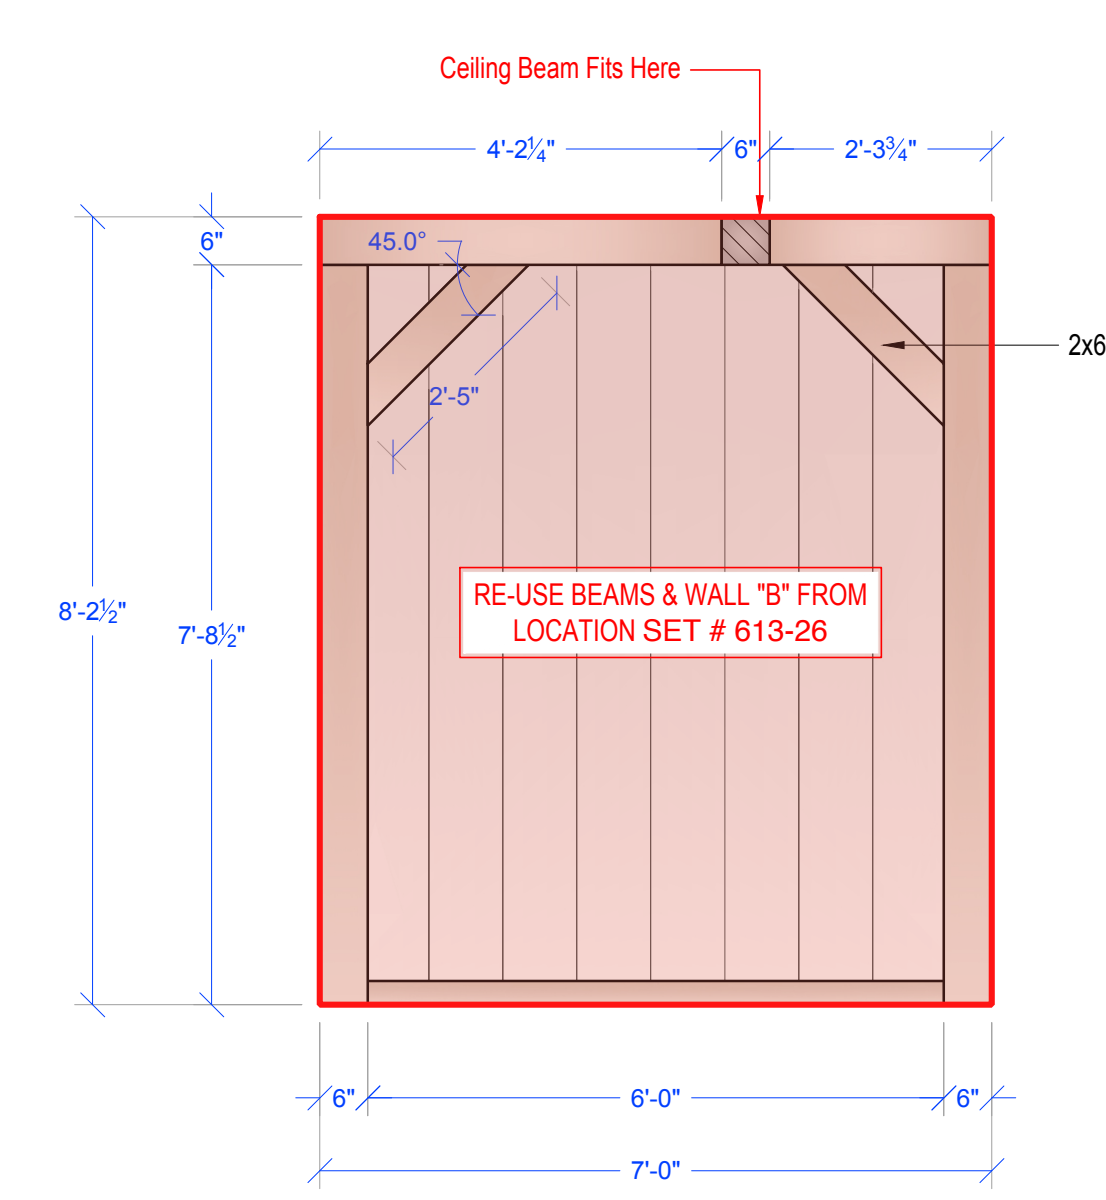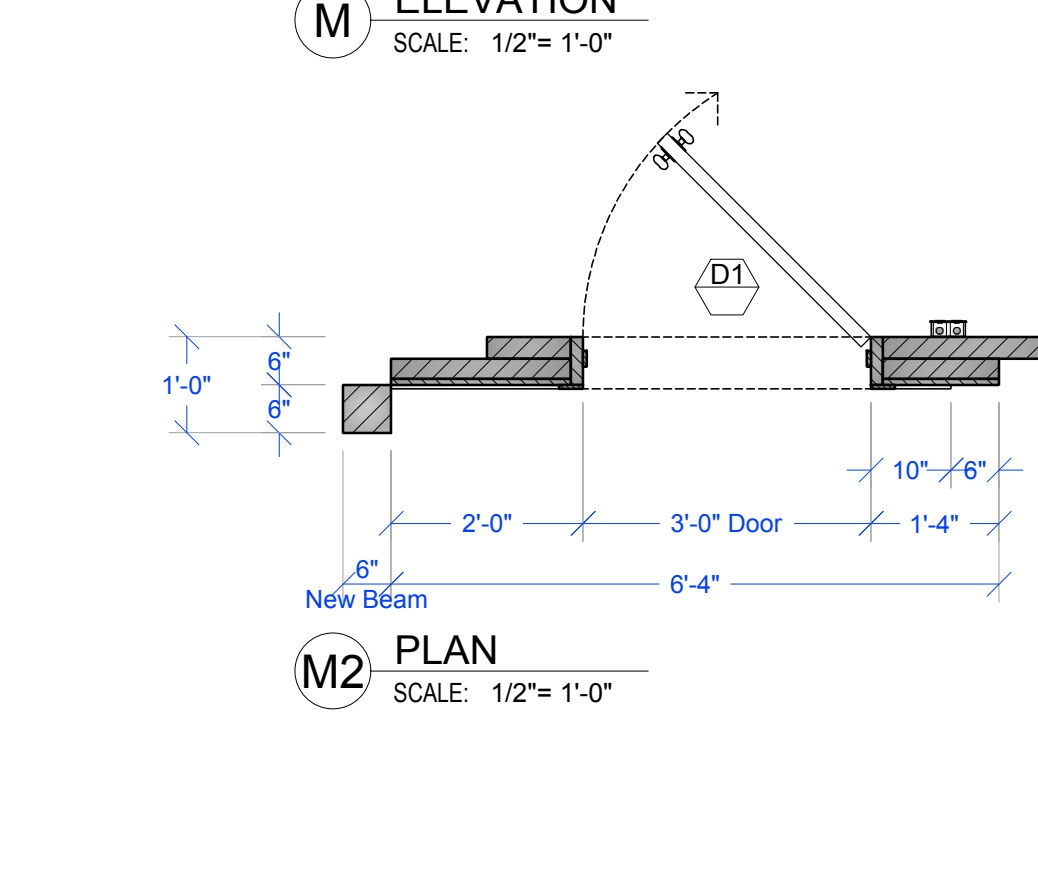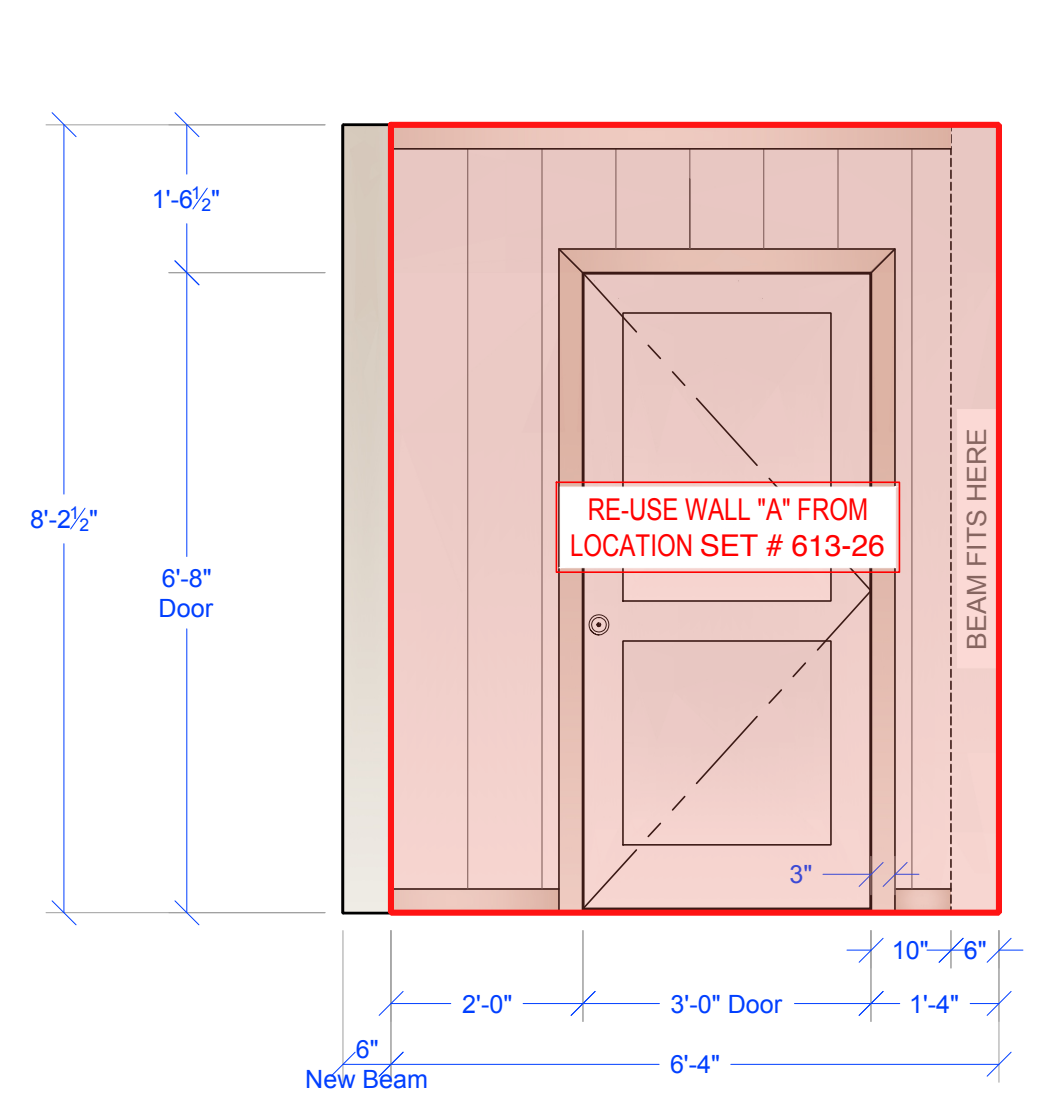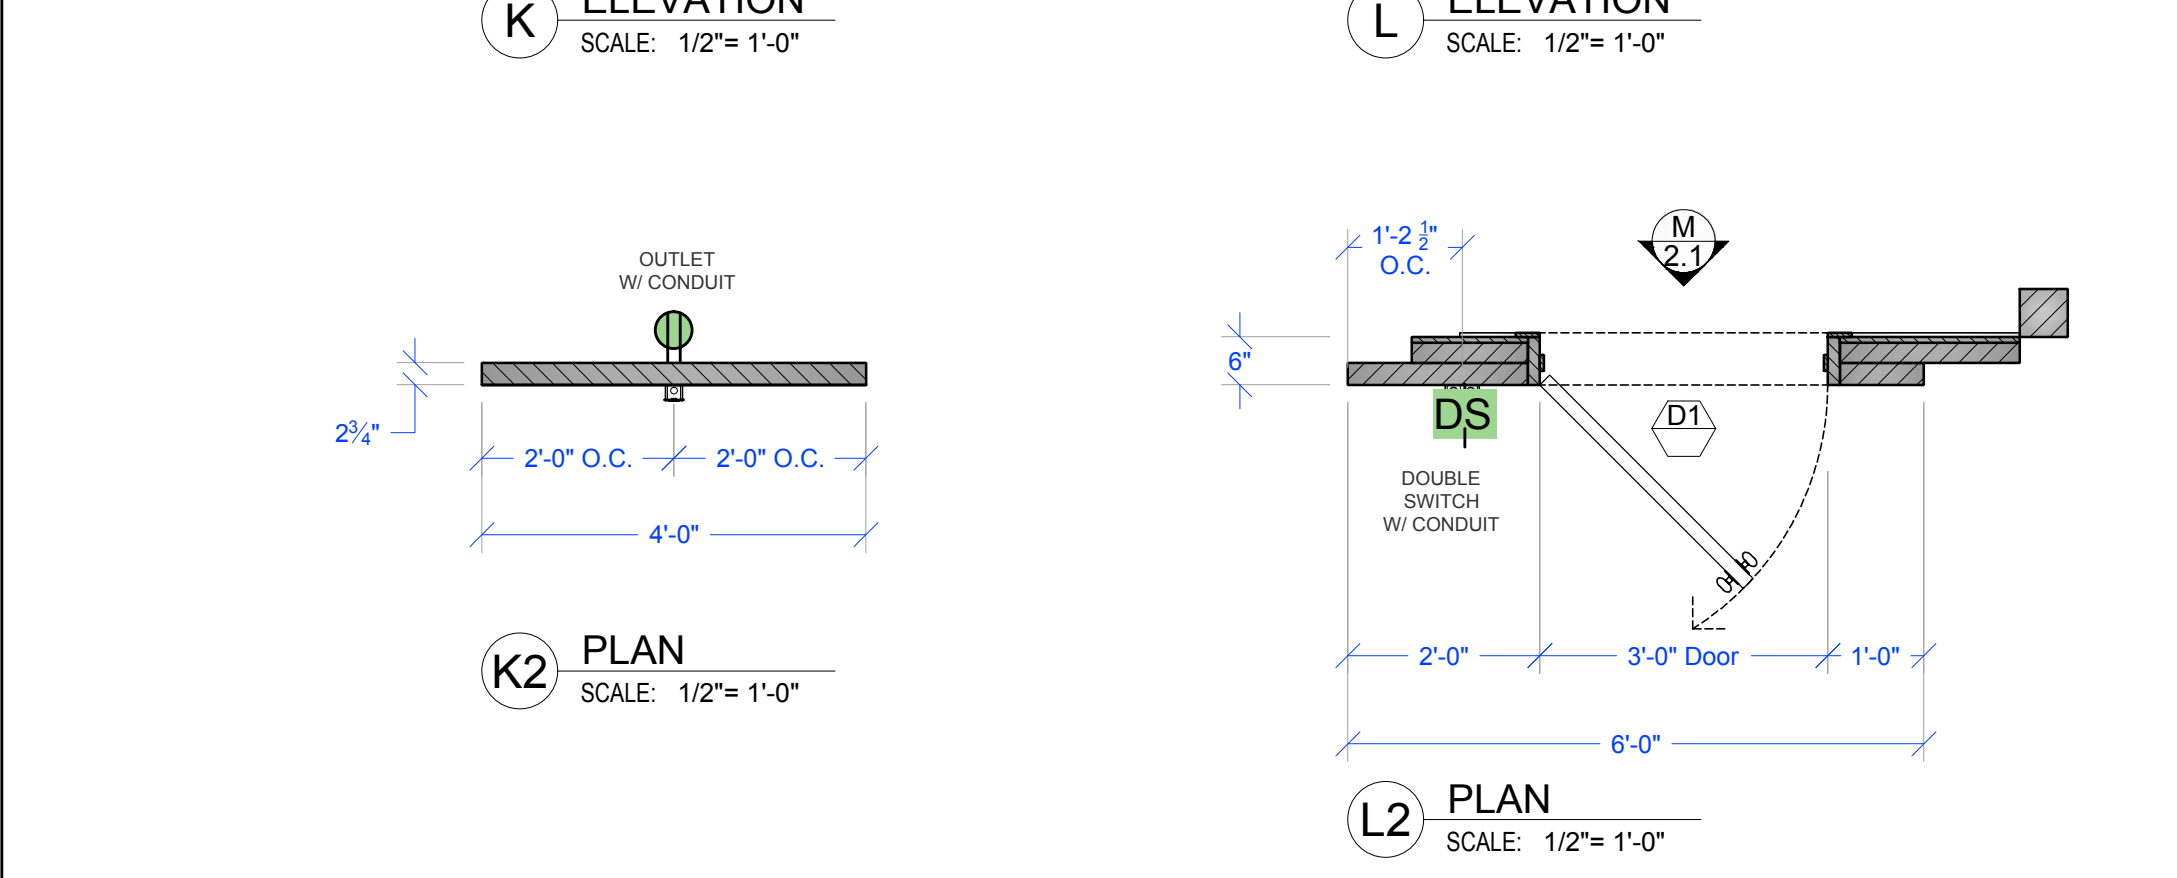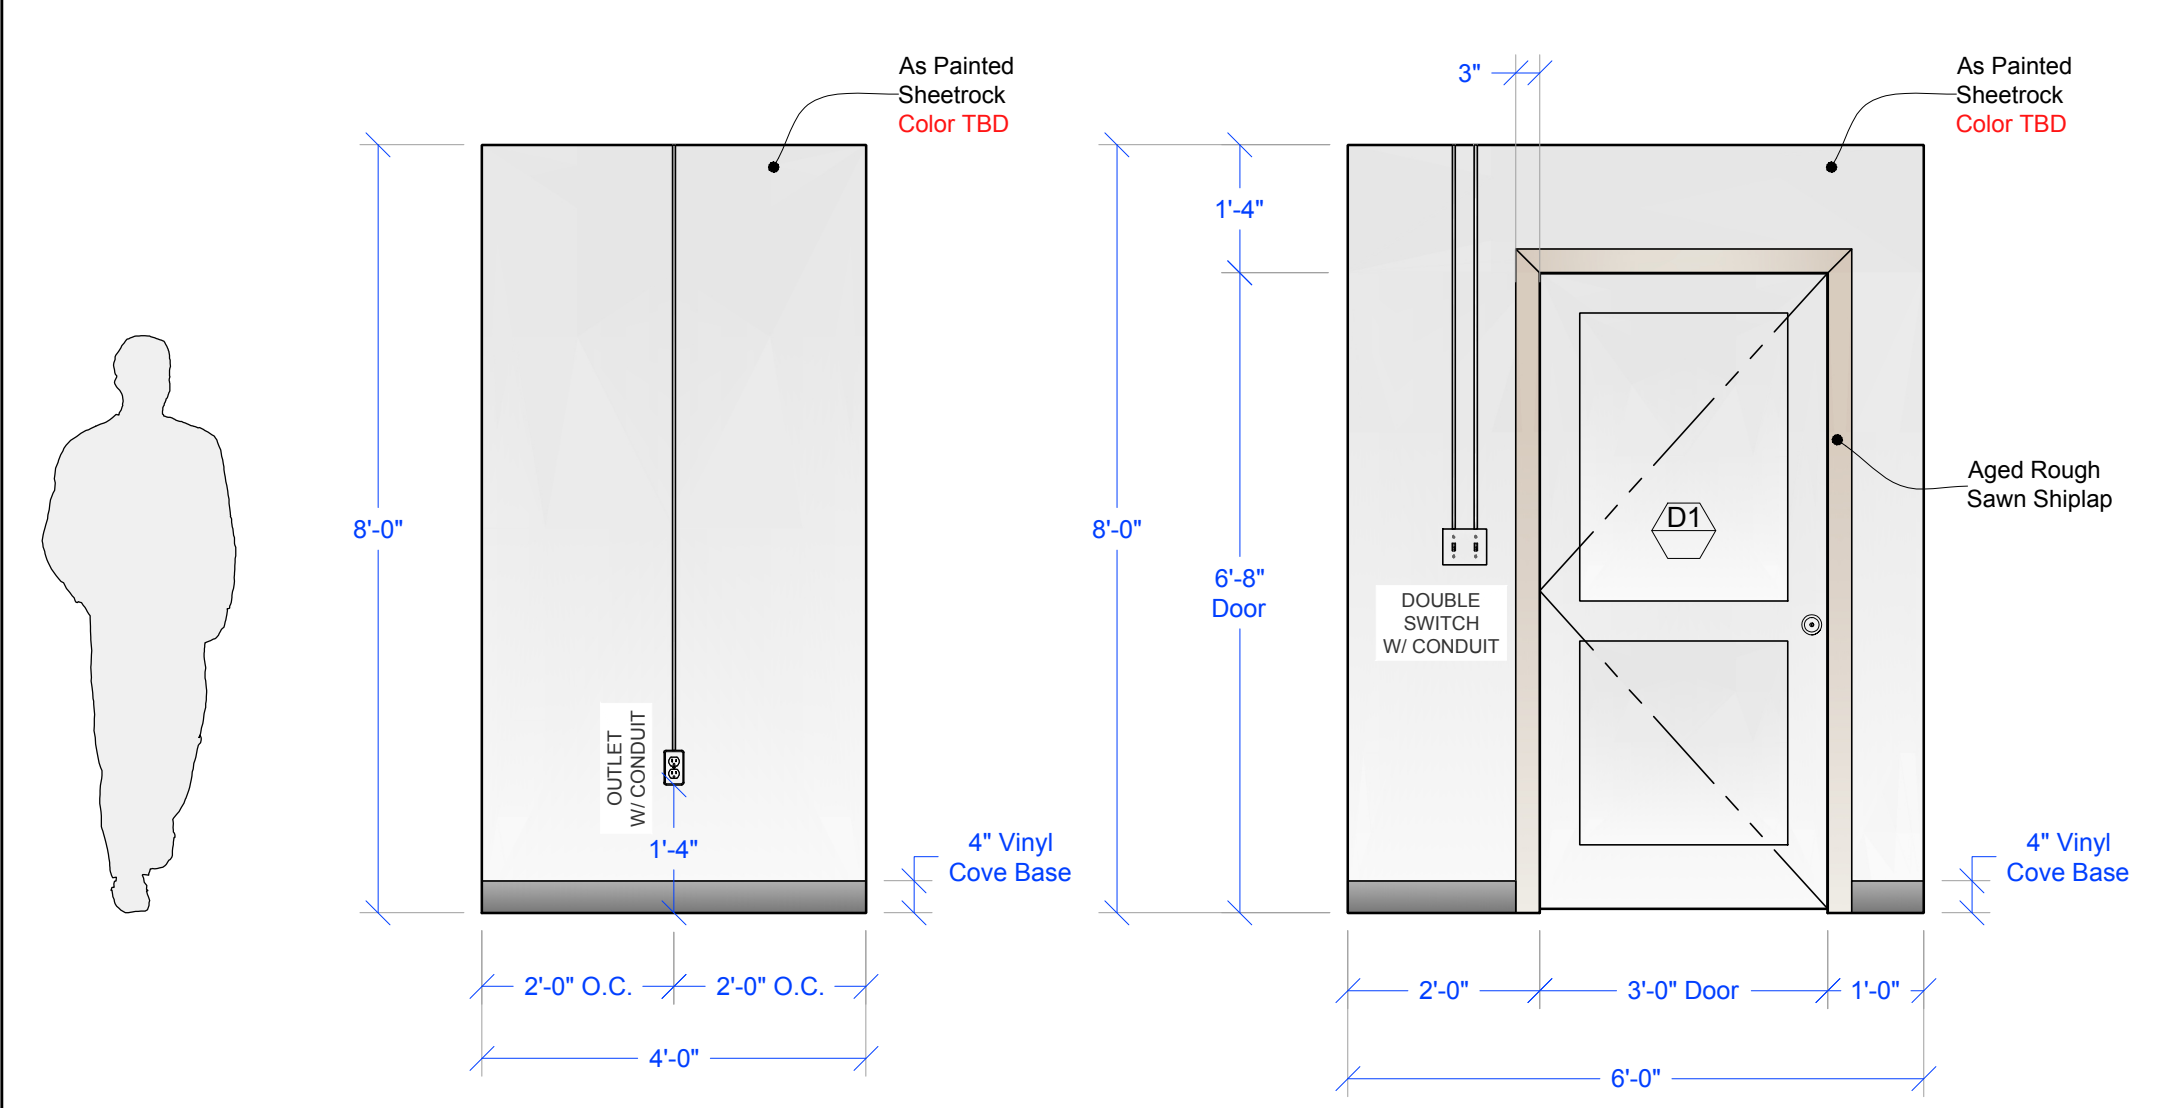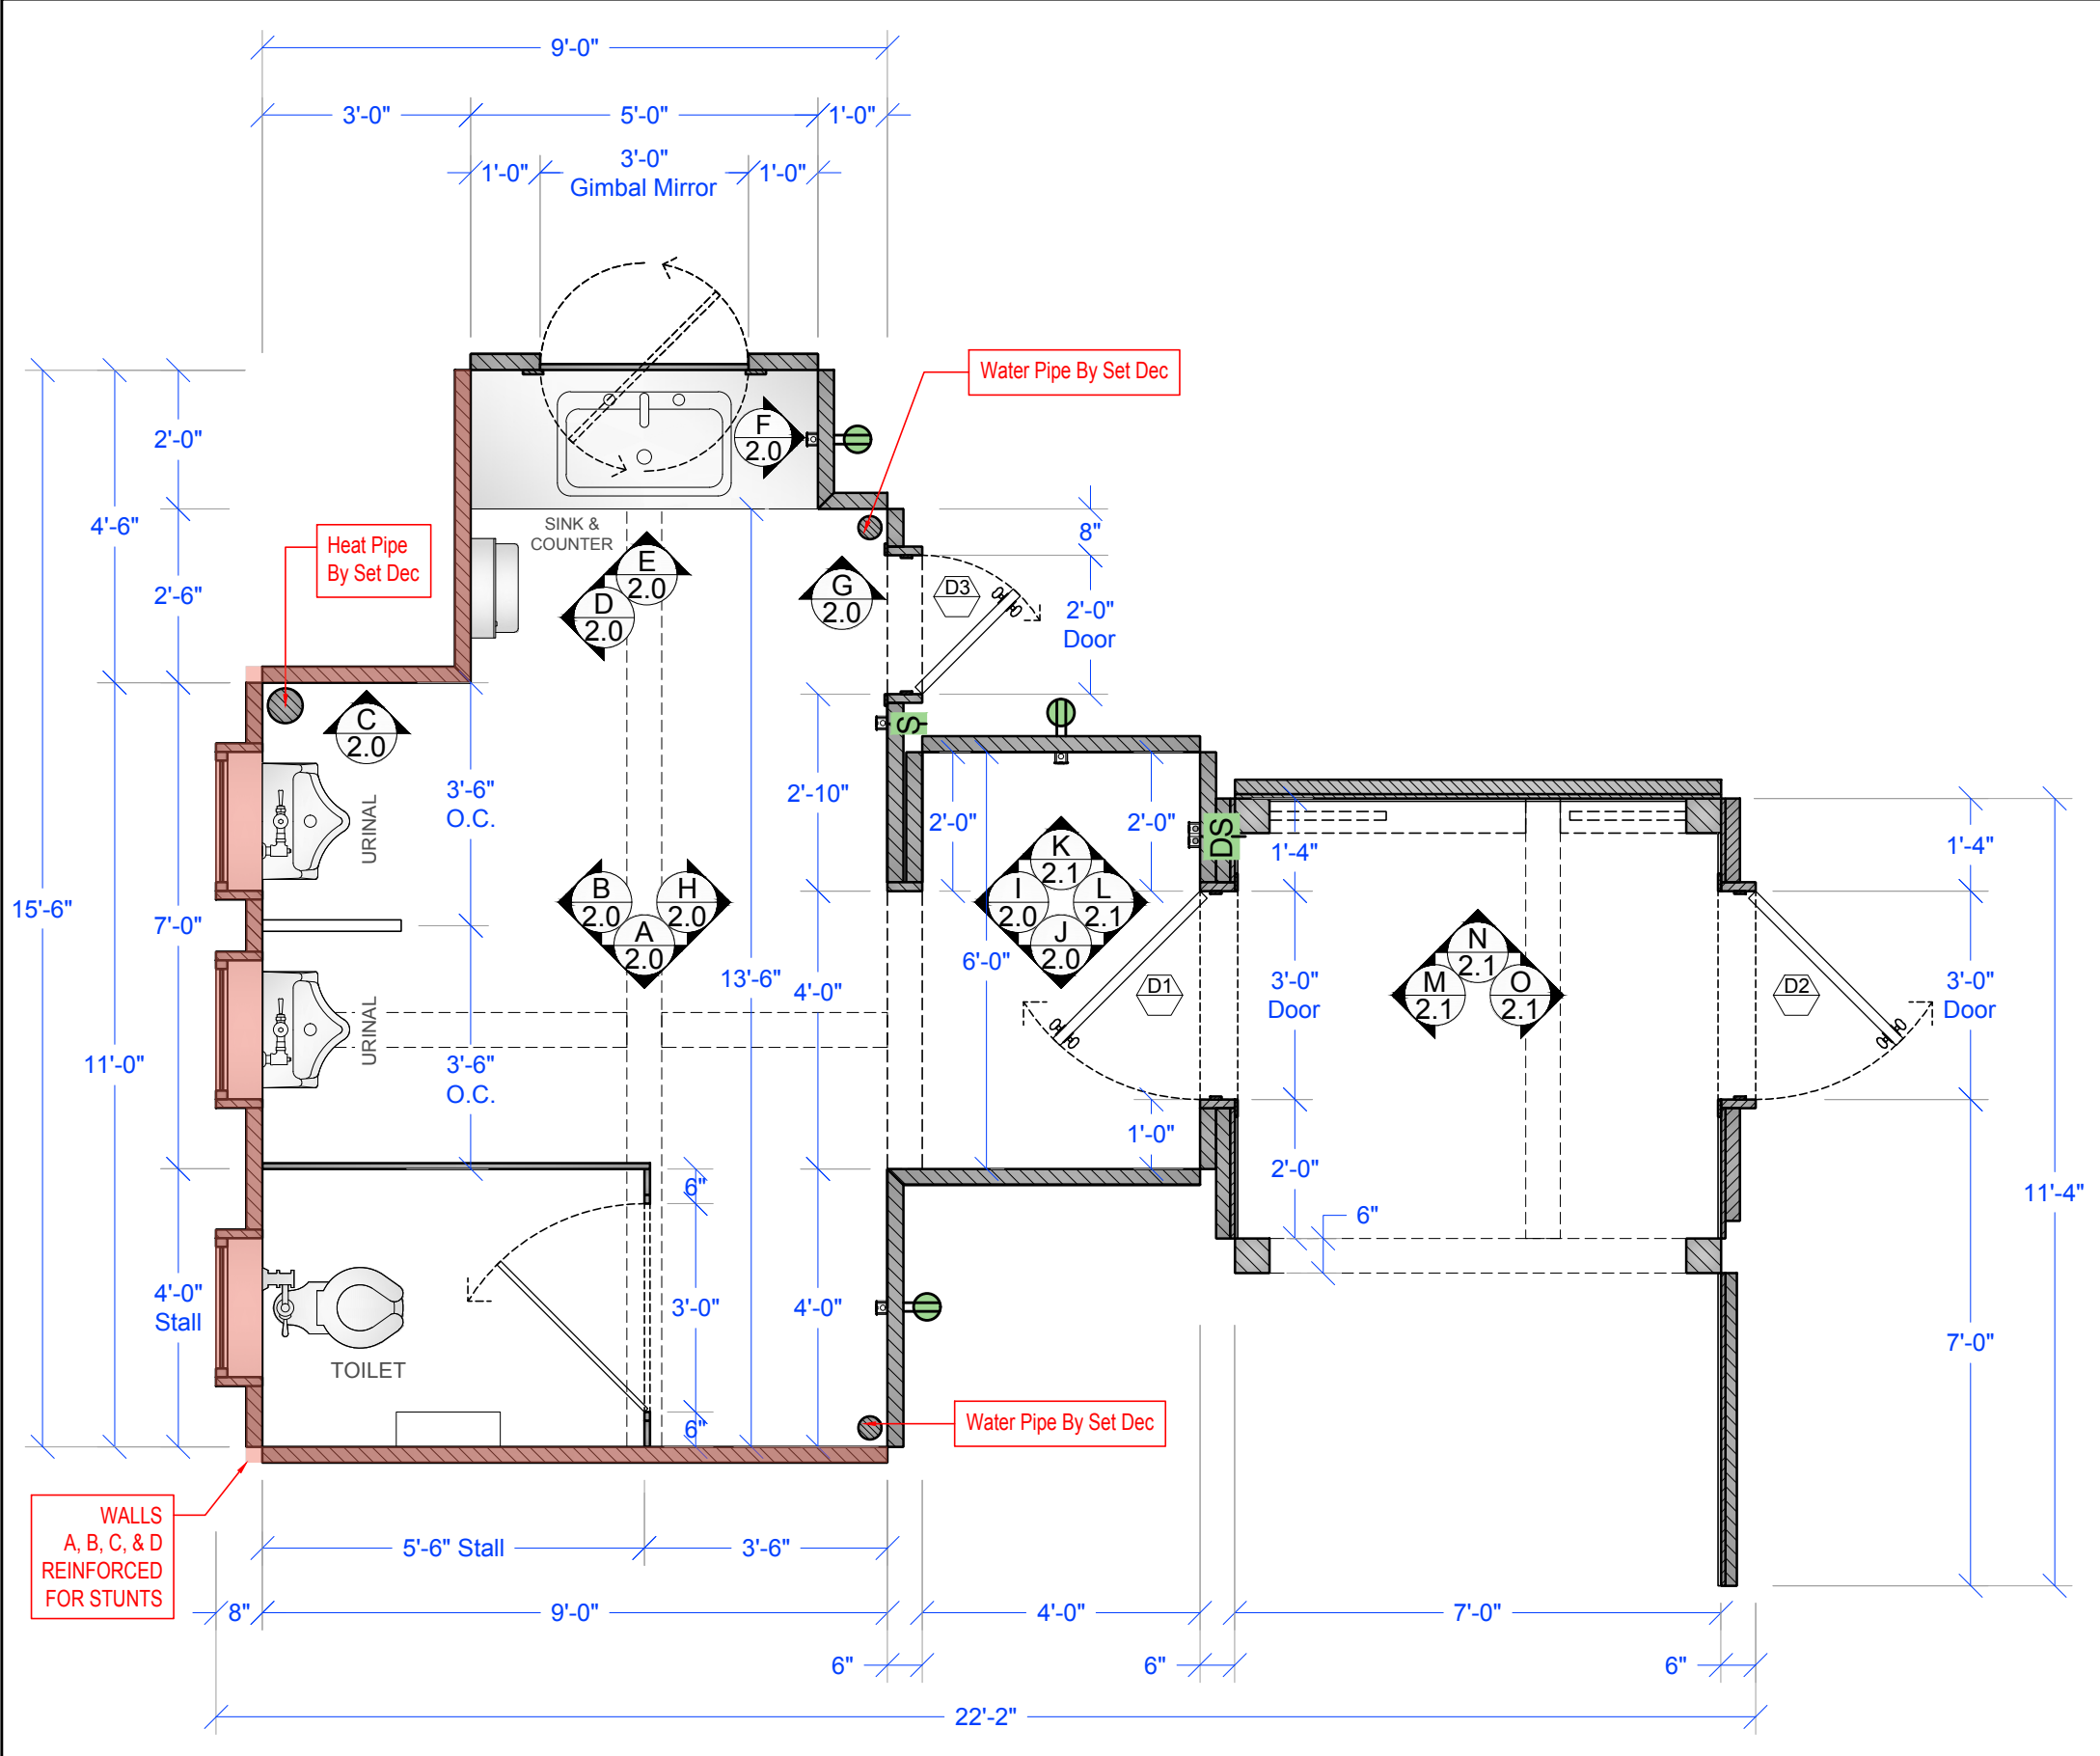

RELEASED
12-17-2024
SHOOT DATE: 01.09.25



1895 125 2020

FBI MOST WANTED
SEASON 6

PRODUCTION DESIGNER: KARA ZEIGON
ART DIRECTOR: CHRIS THOMPSON
SET DECORATOR: TORA PETERSON

DRAWING NAME: WINDOW DETAILS
SET NAME: 613-12 Int. College Bar Bathroom (VA)
LOCATION: Stage 24










SCALE: AS NOTED
DATE: 12.17.24
REV:


DRAWN: Colt F.

EPISODE: 613
SET #: 12



PLATE:

3.0

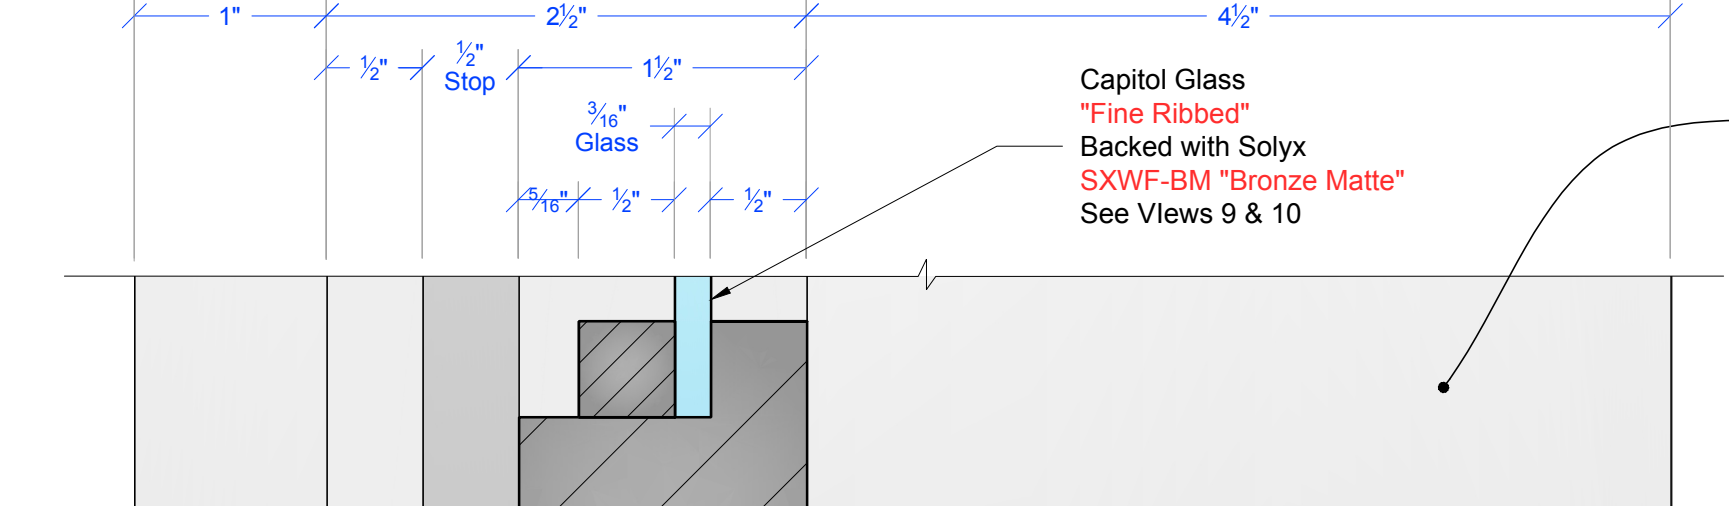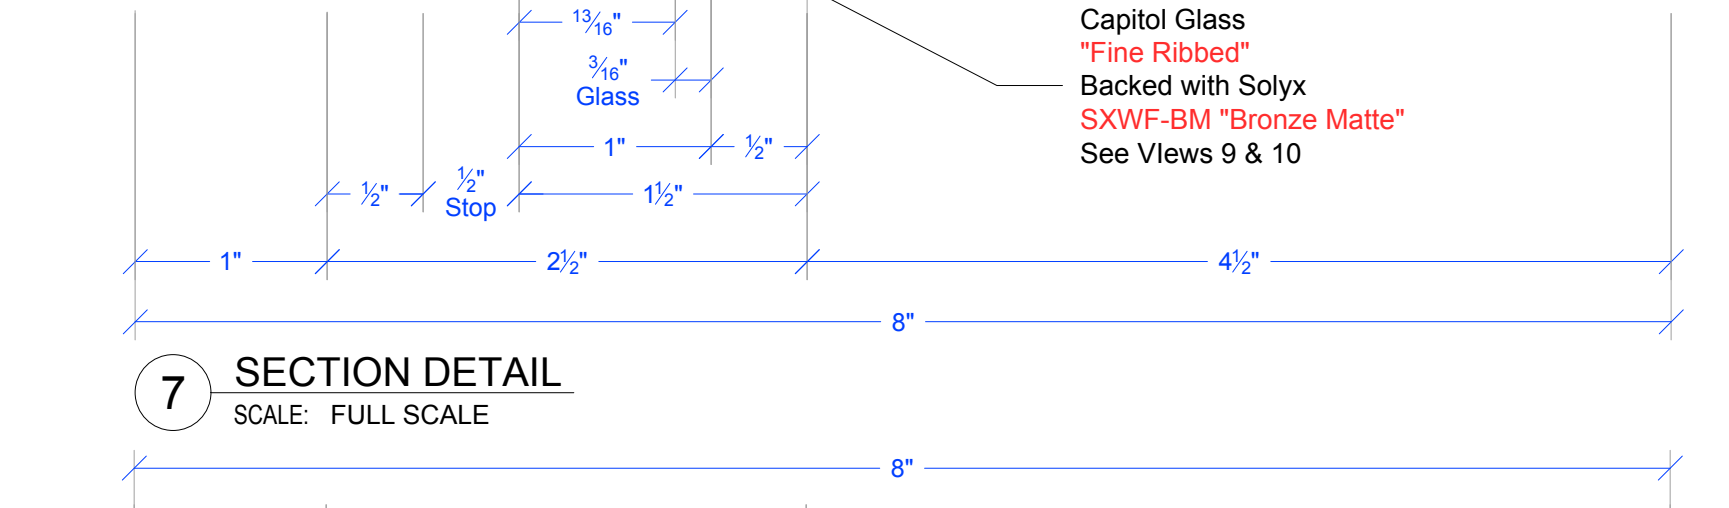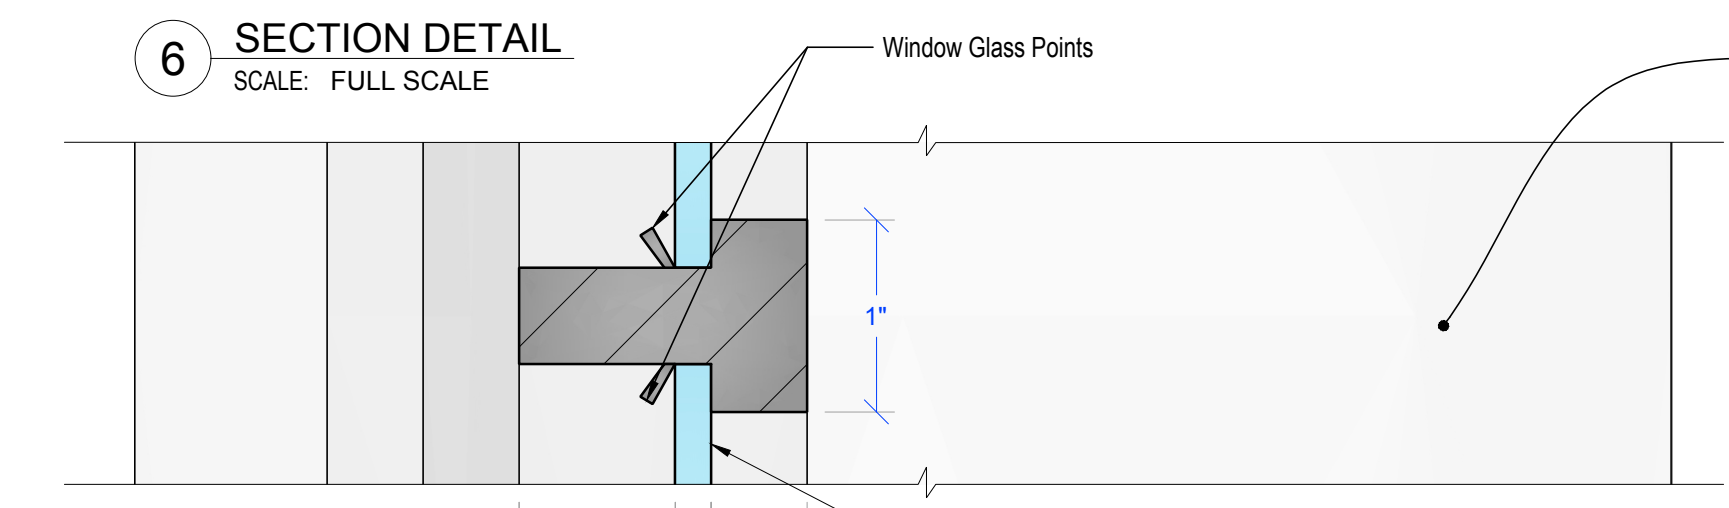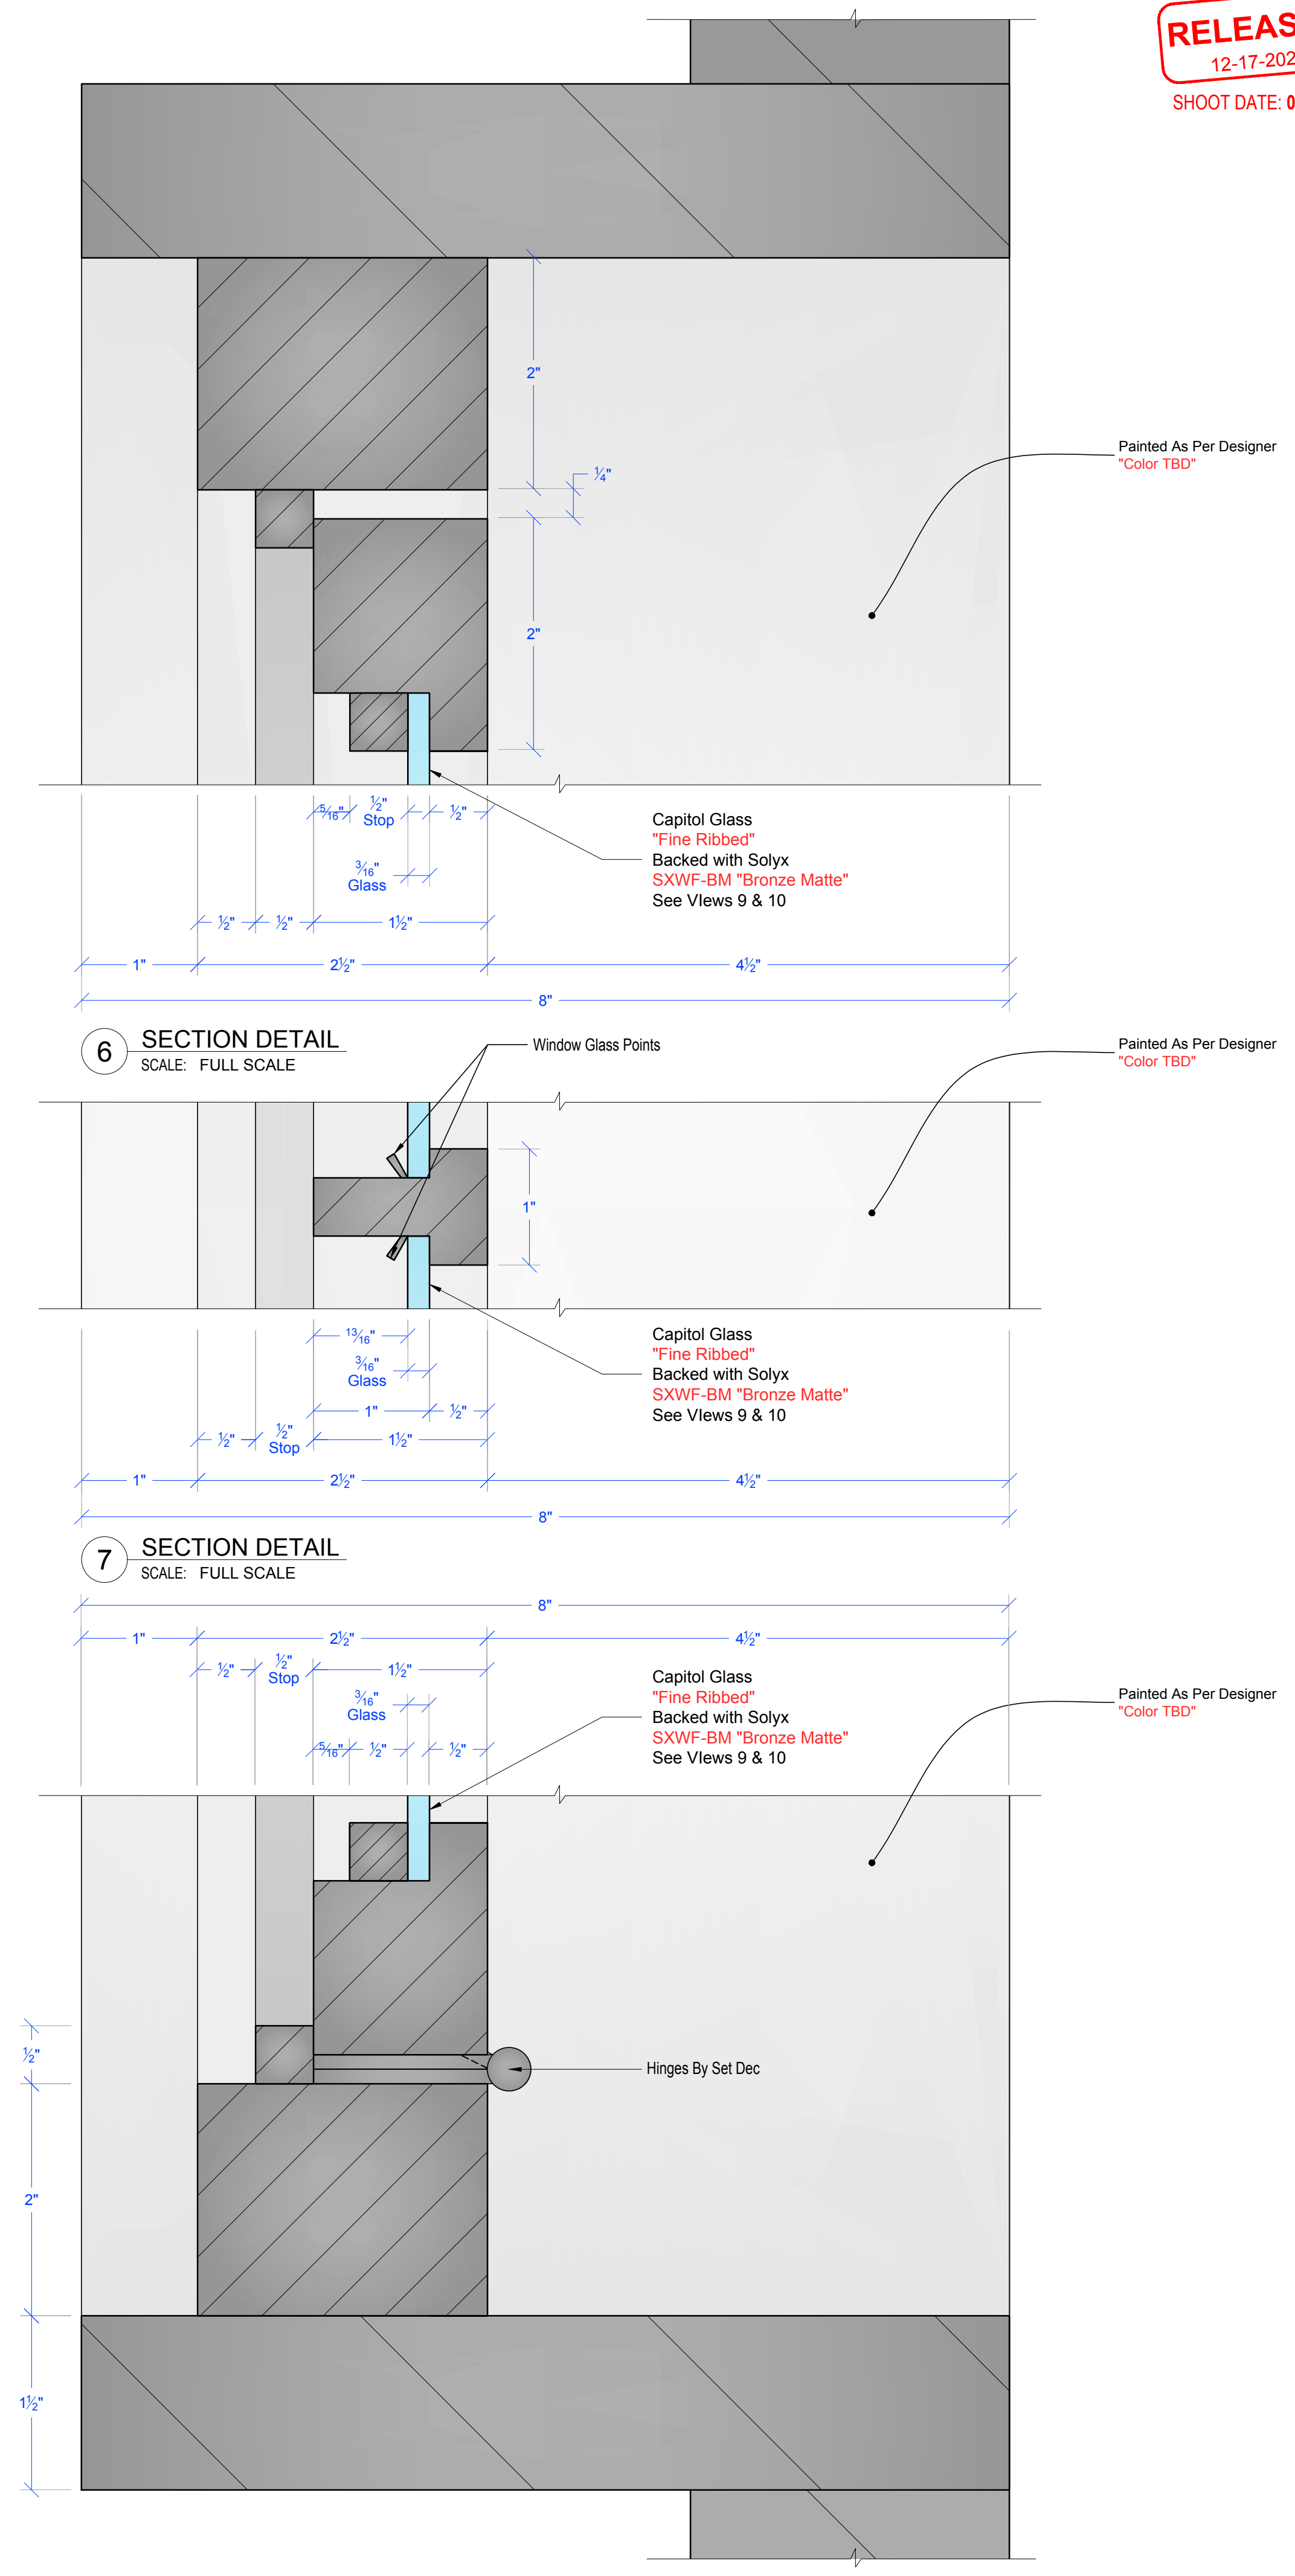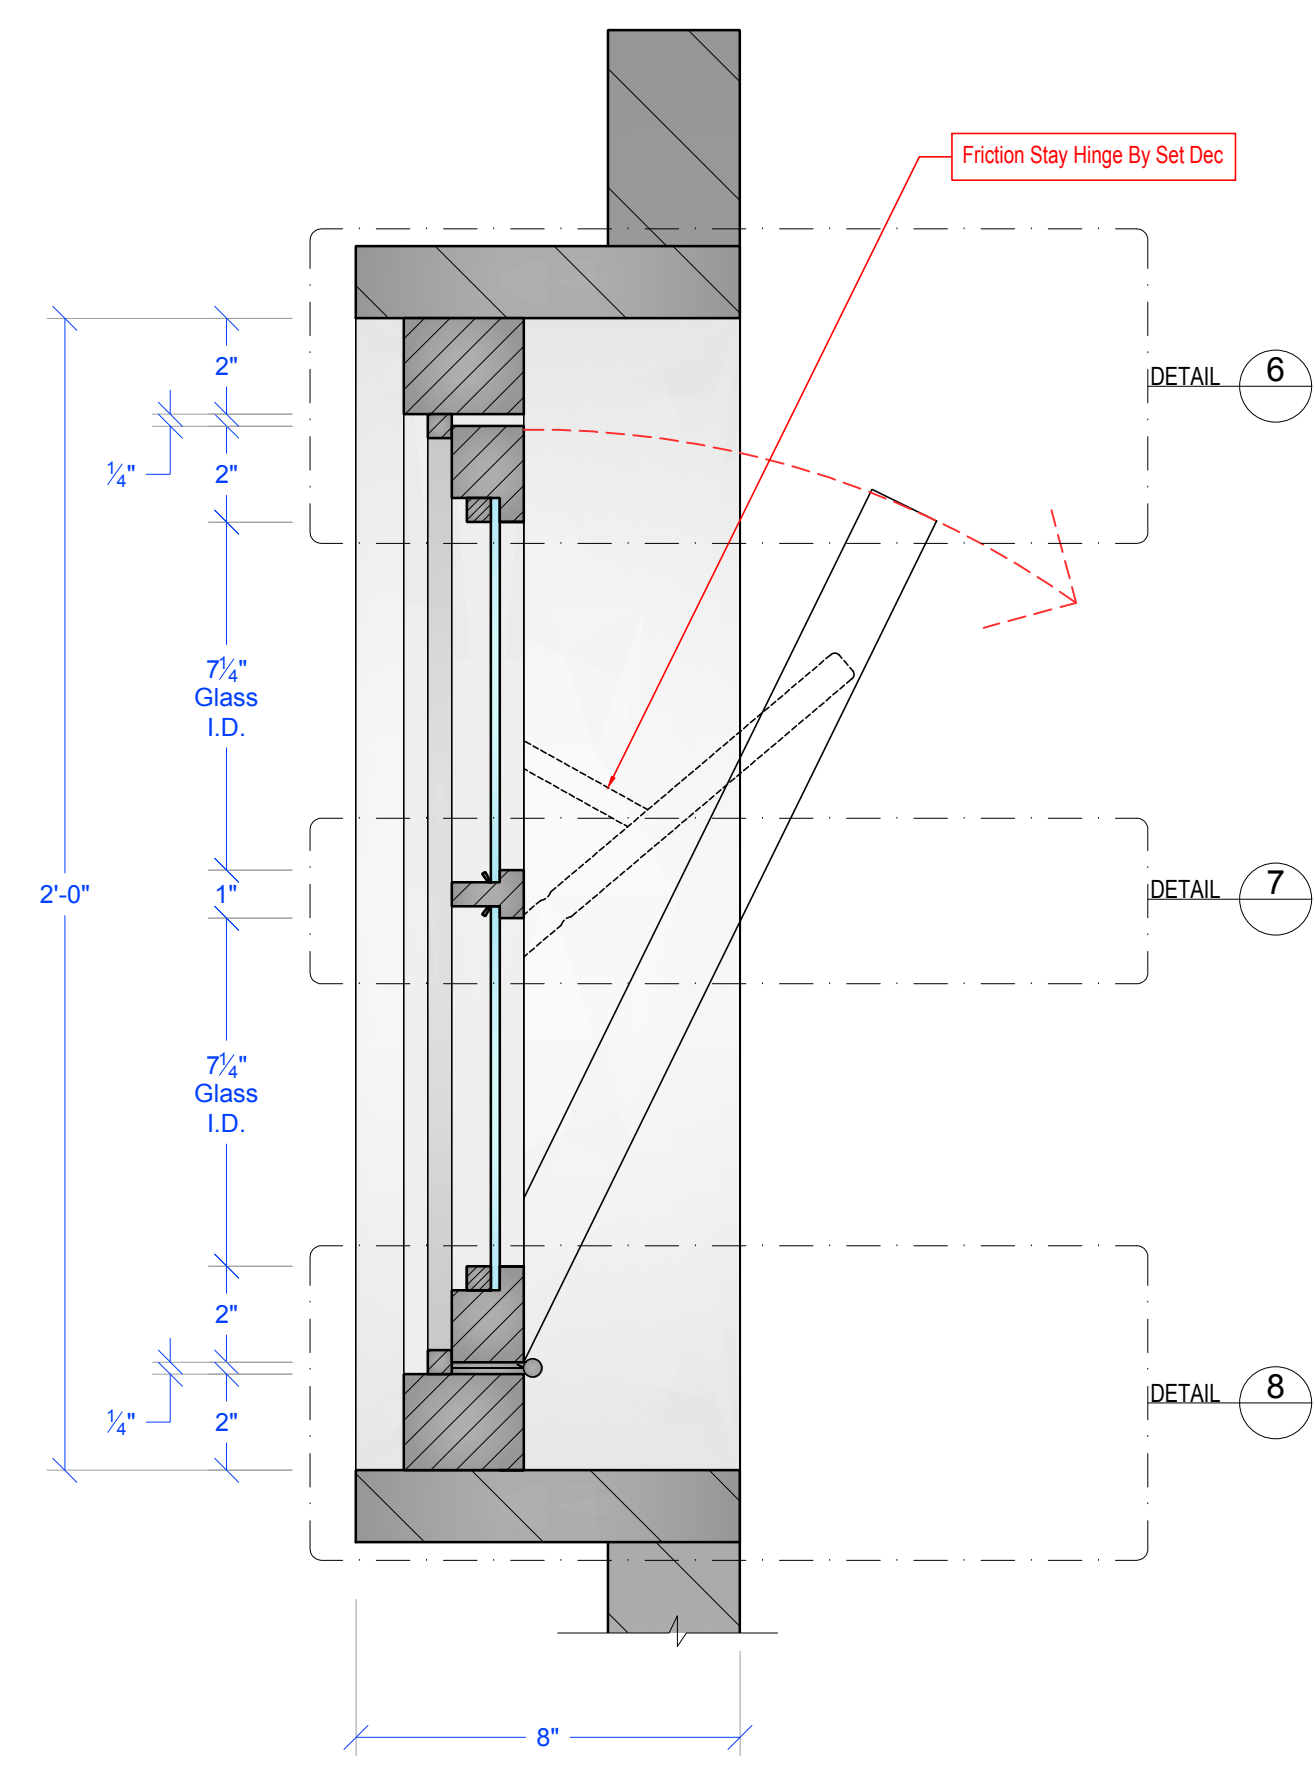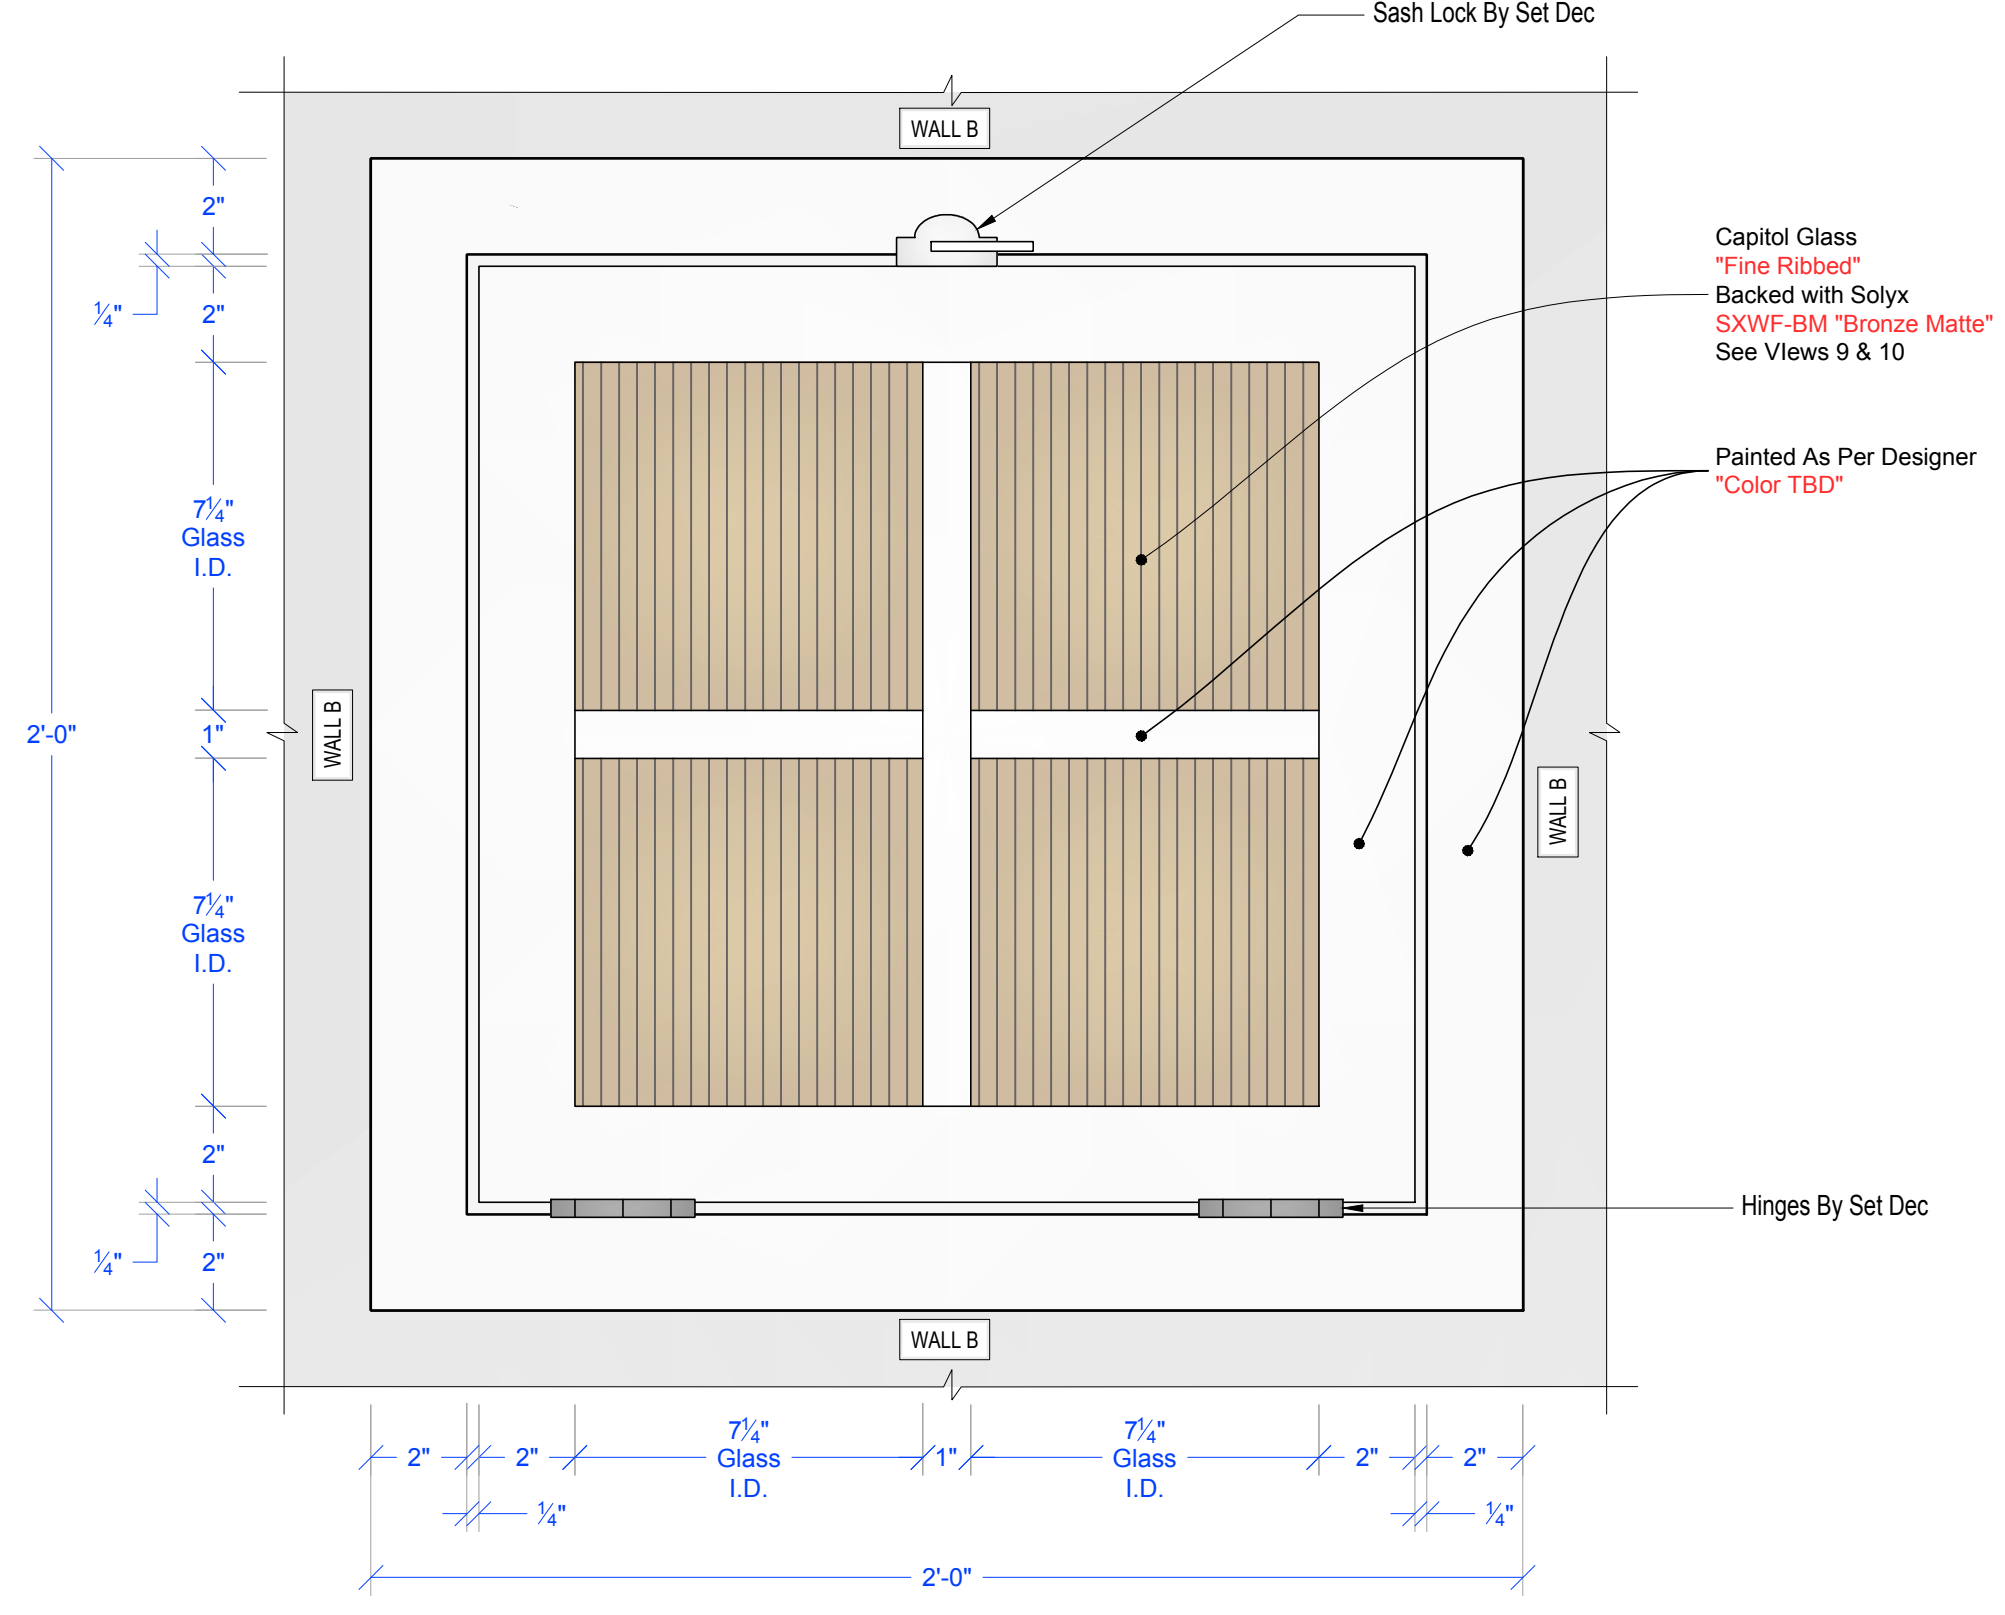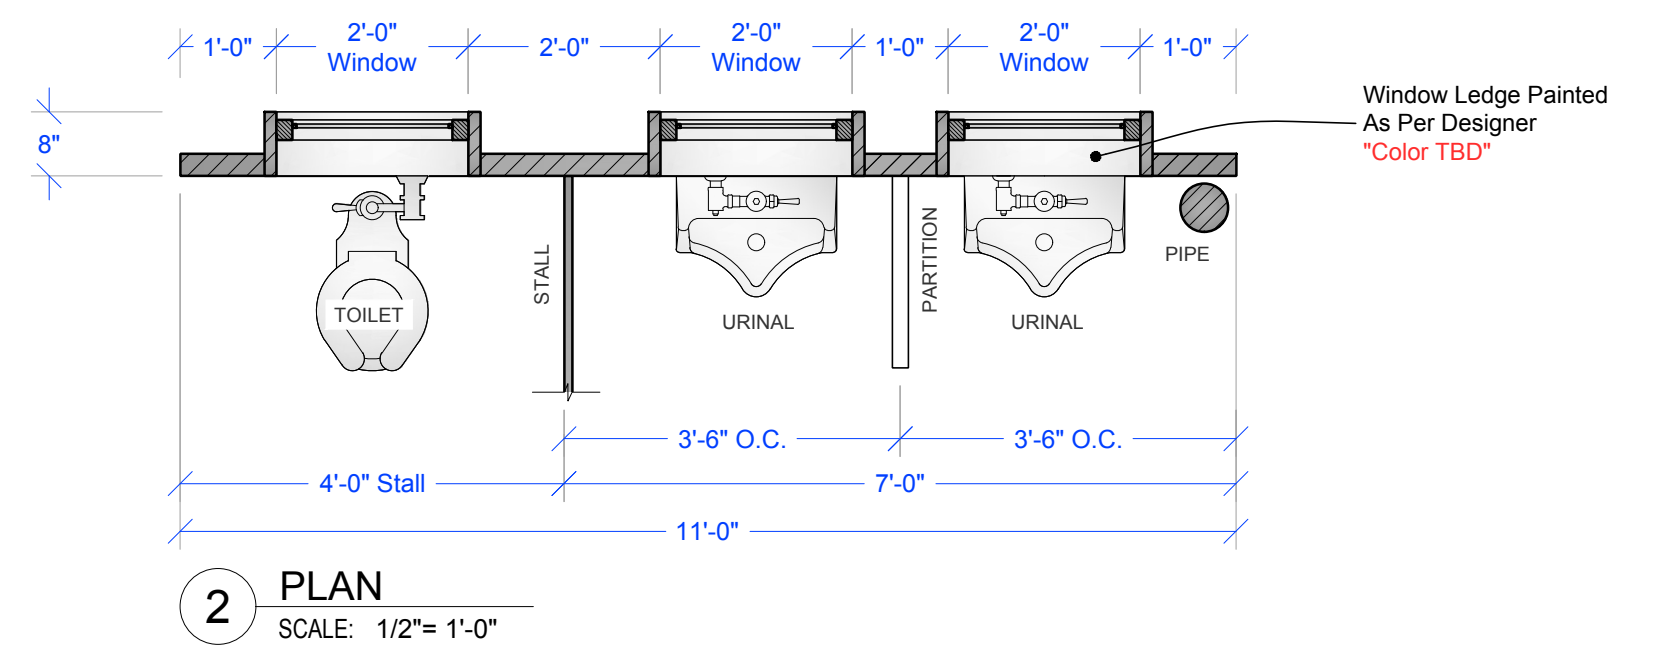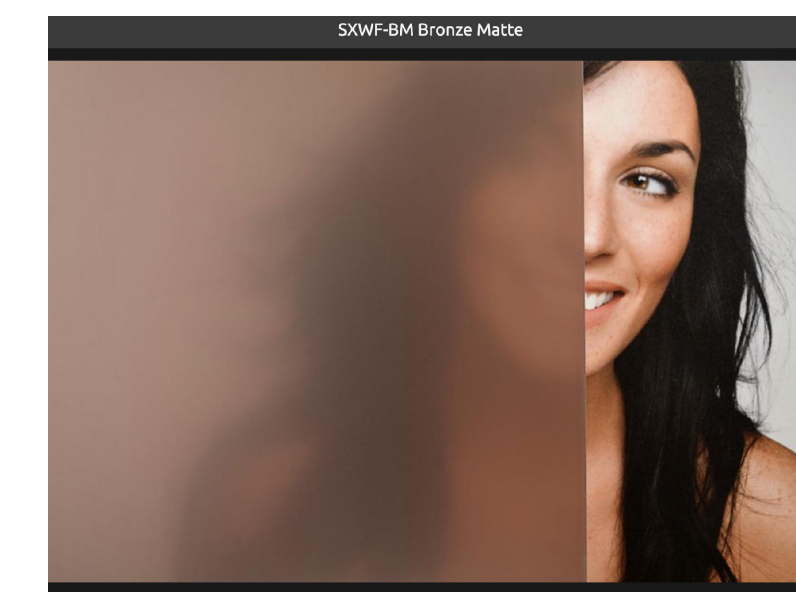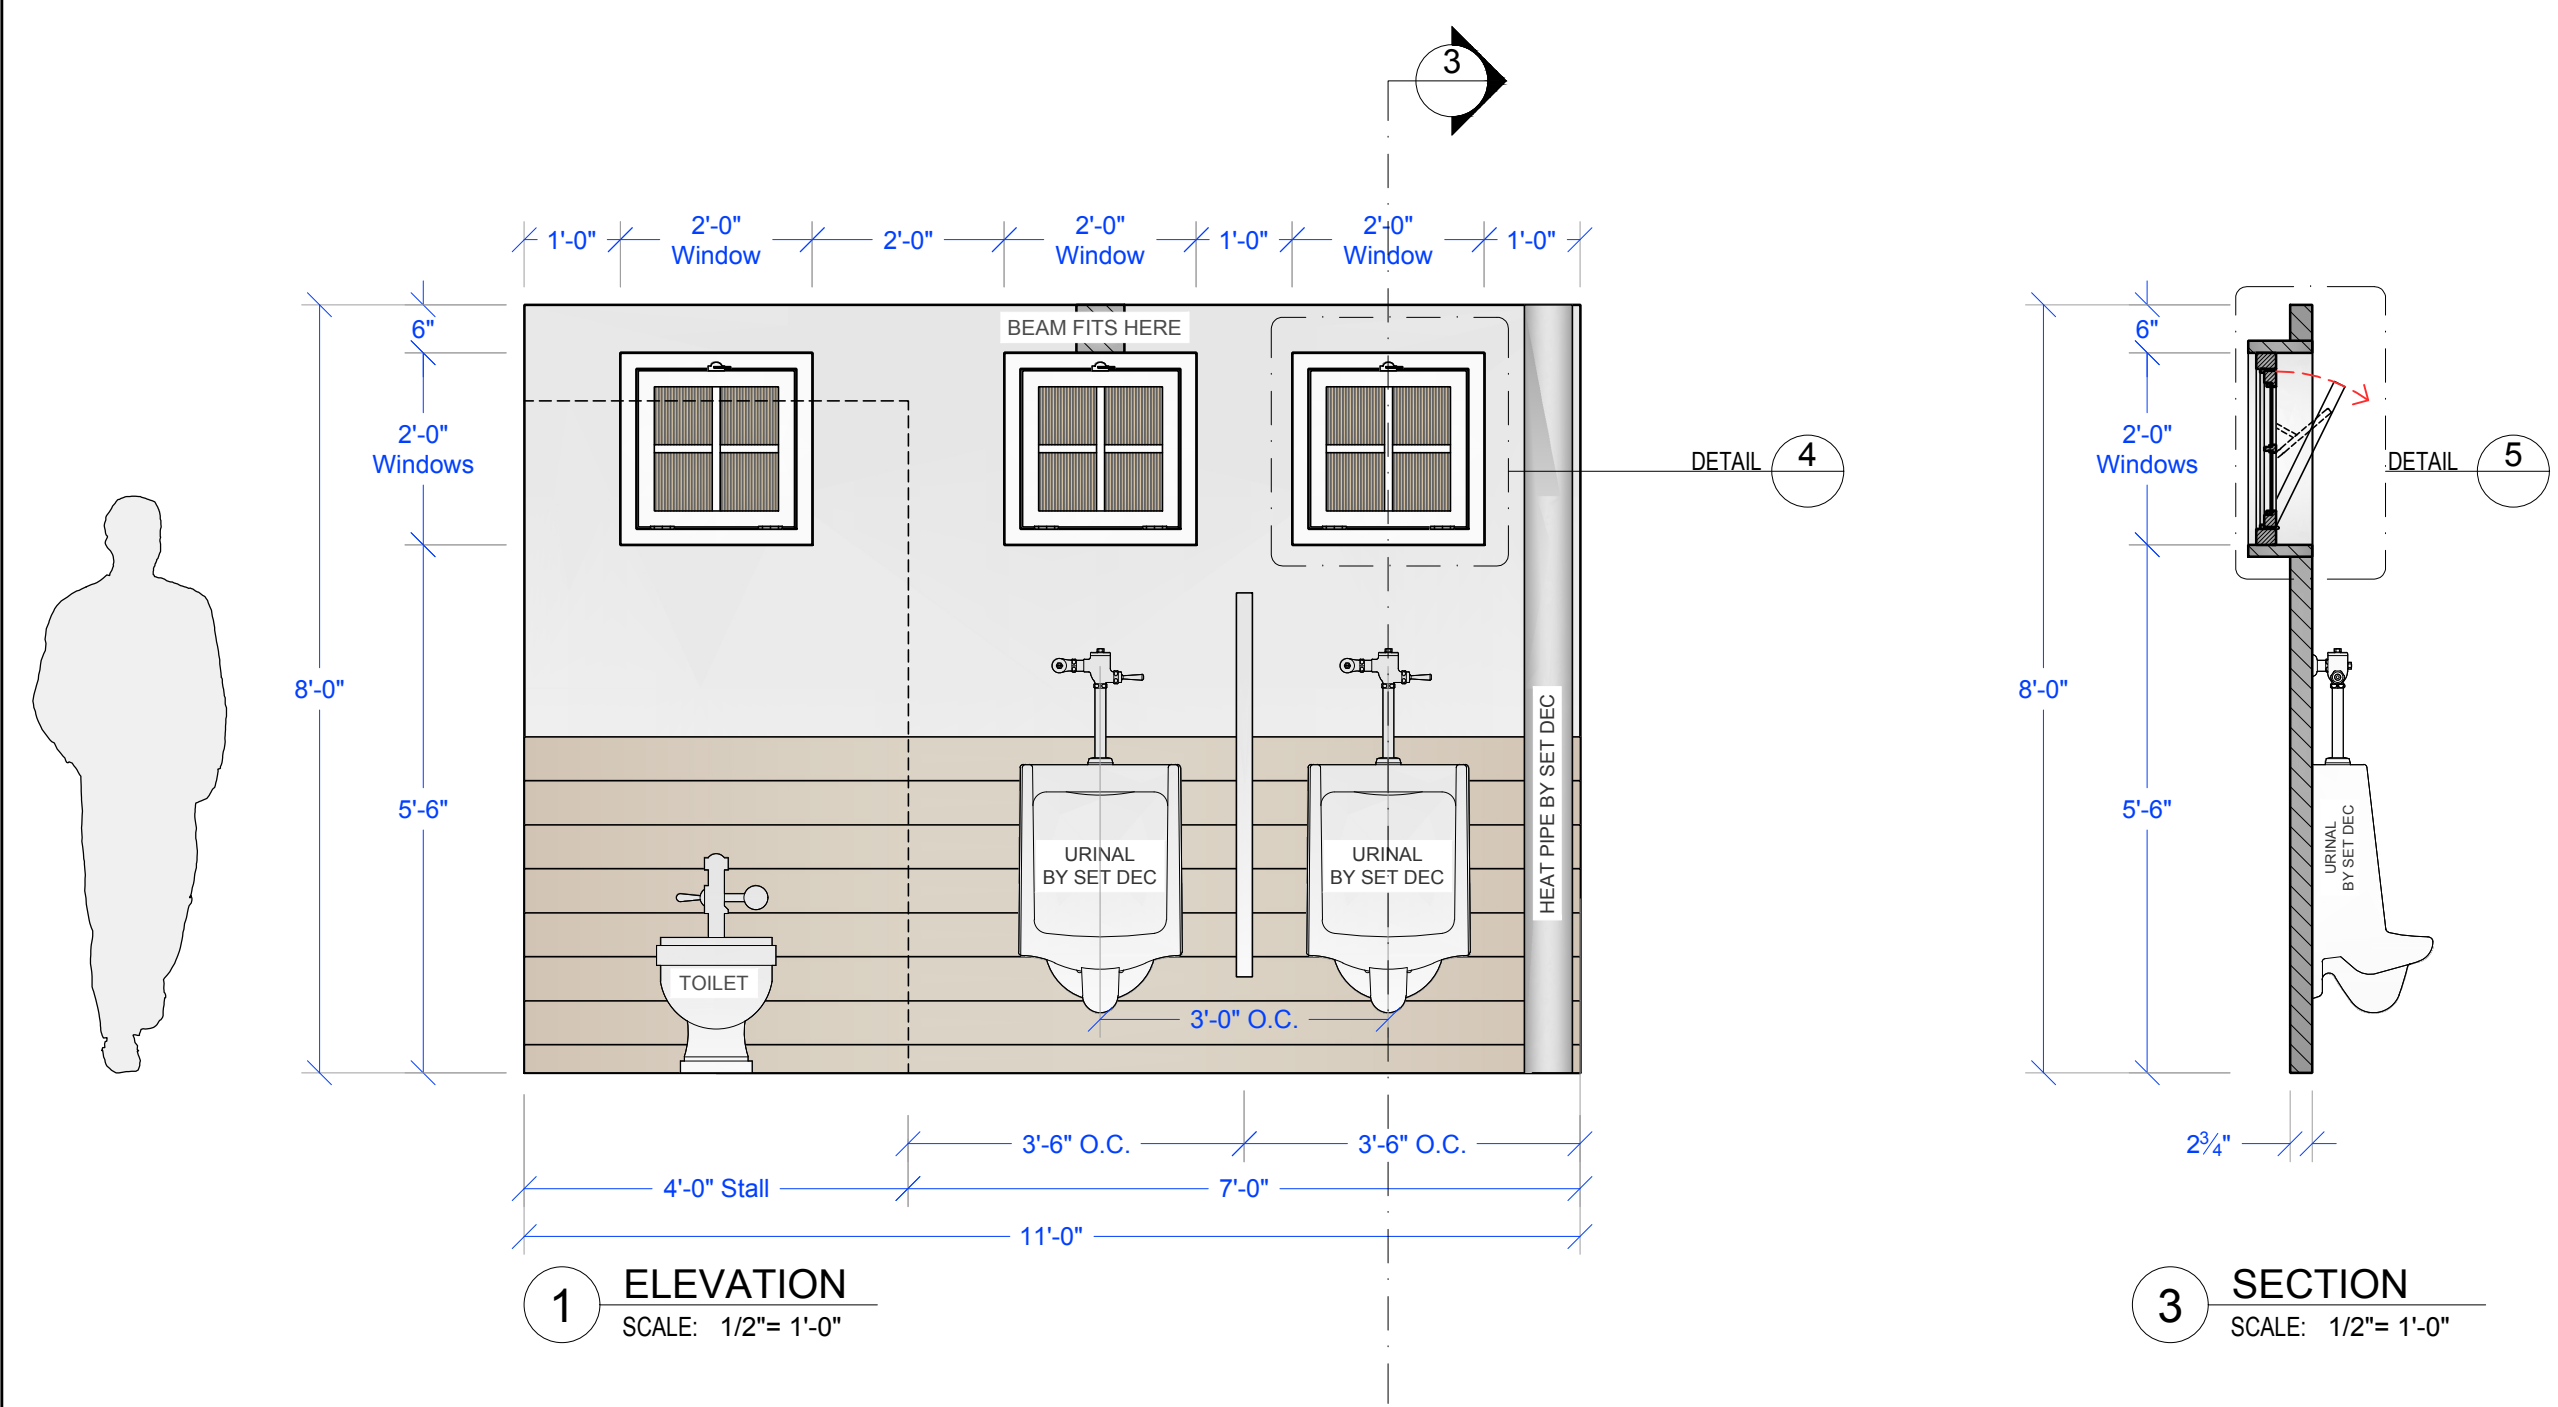


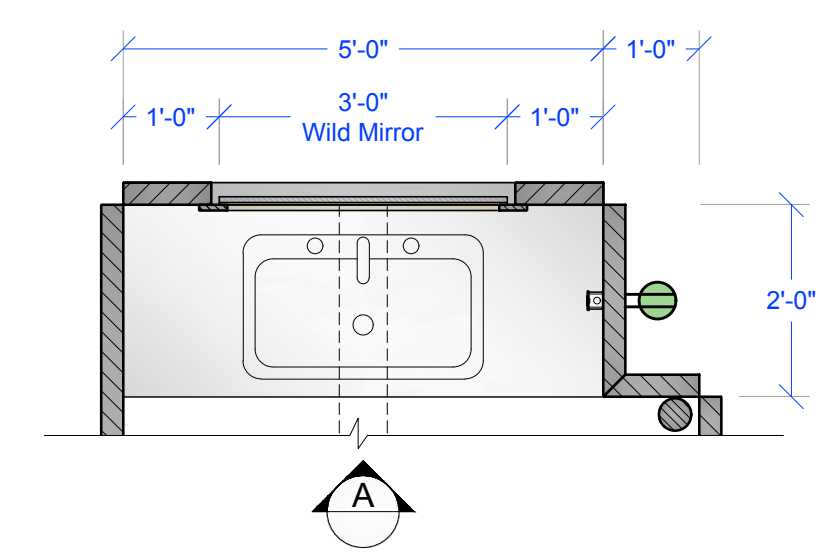


1 SET PLAN
SCALE: 1/2" = 1'-0"

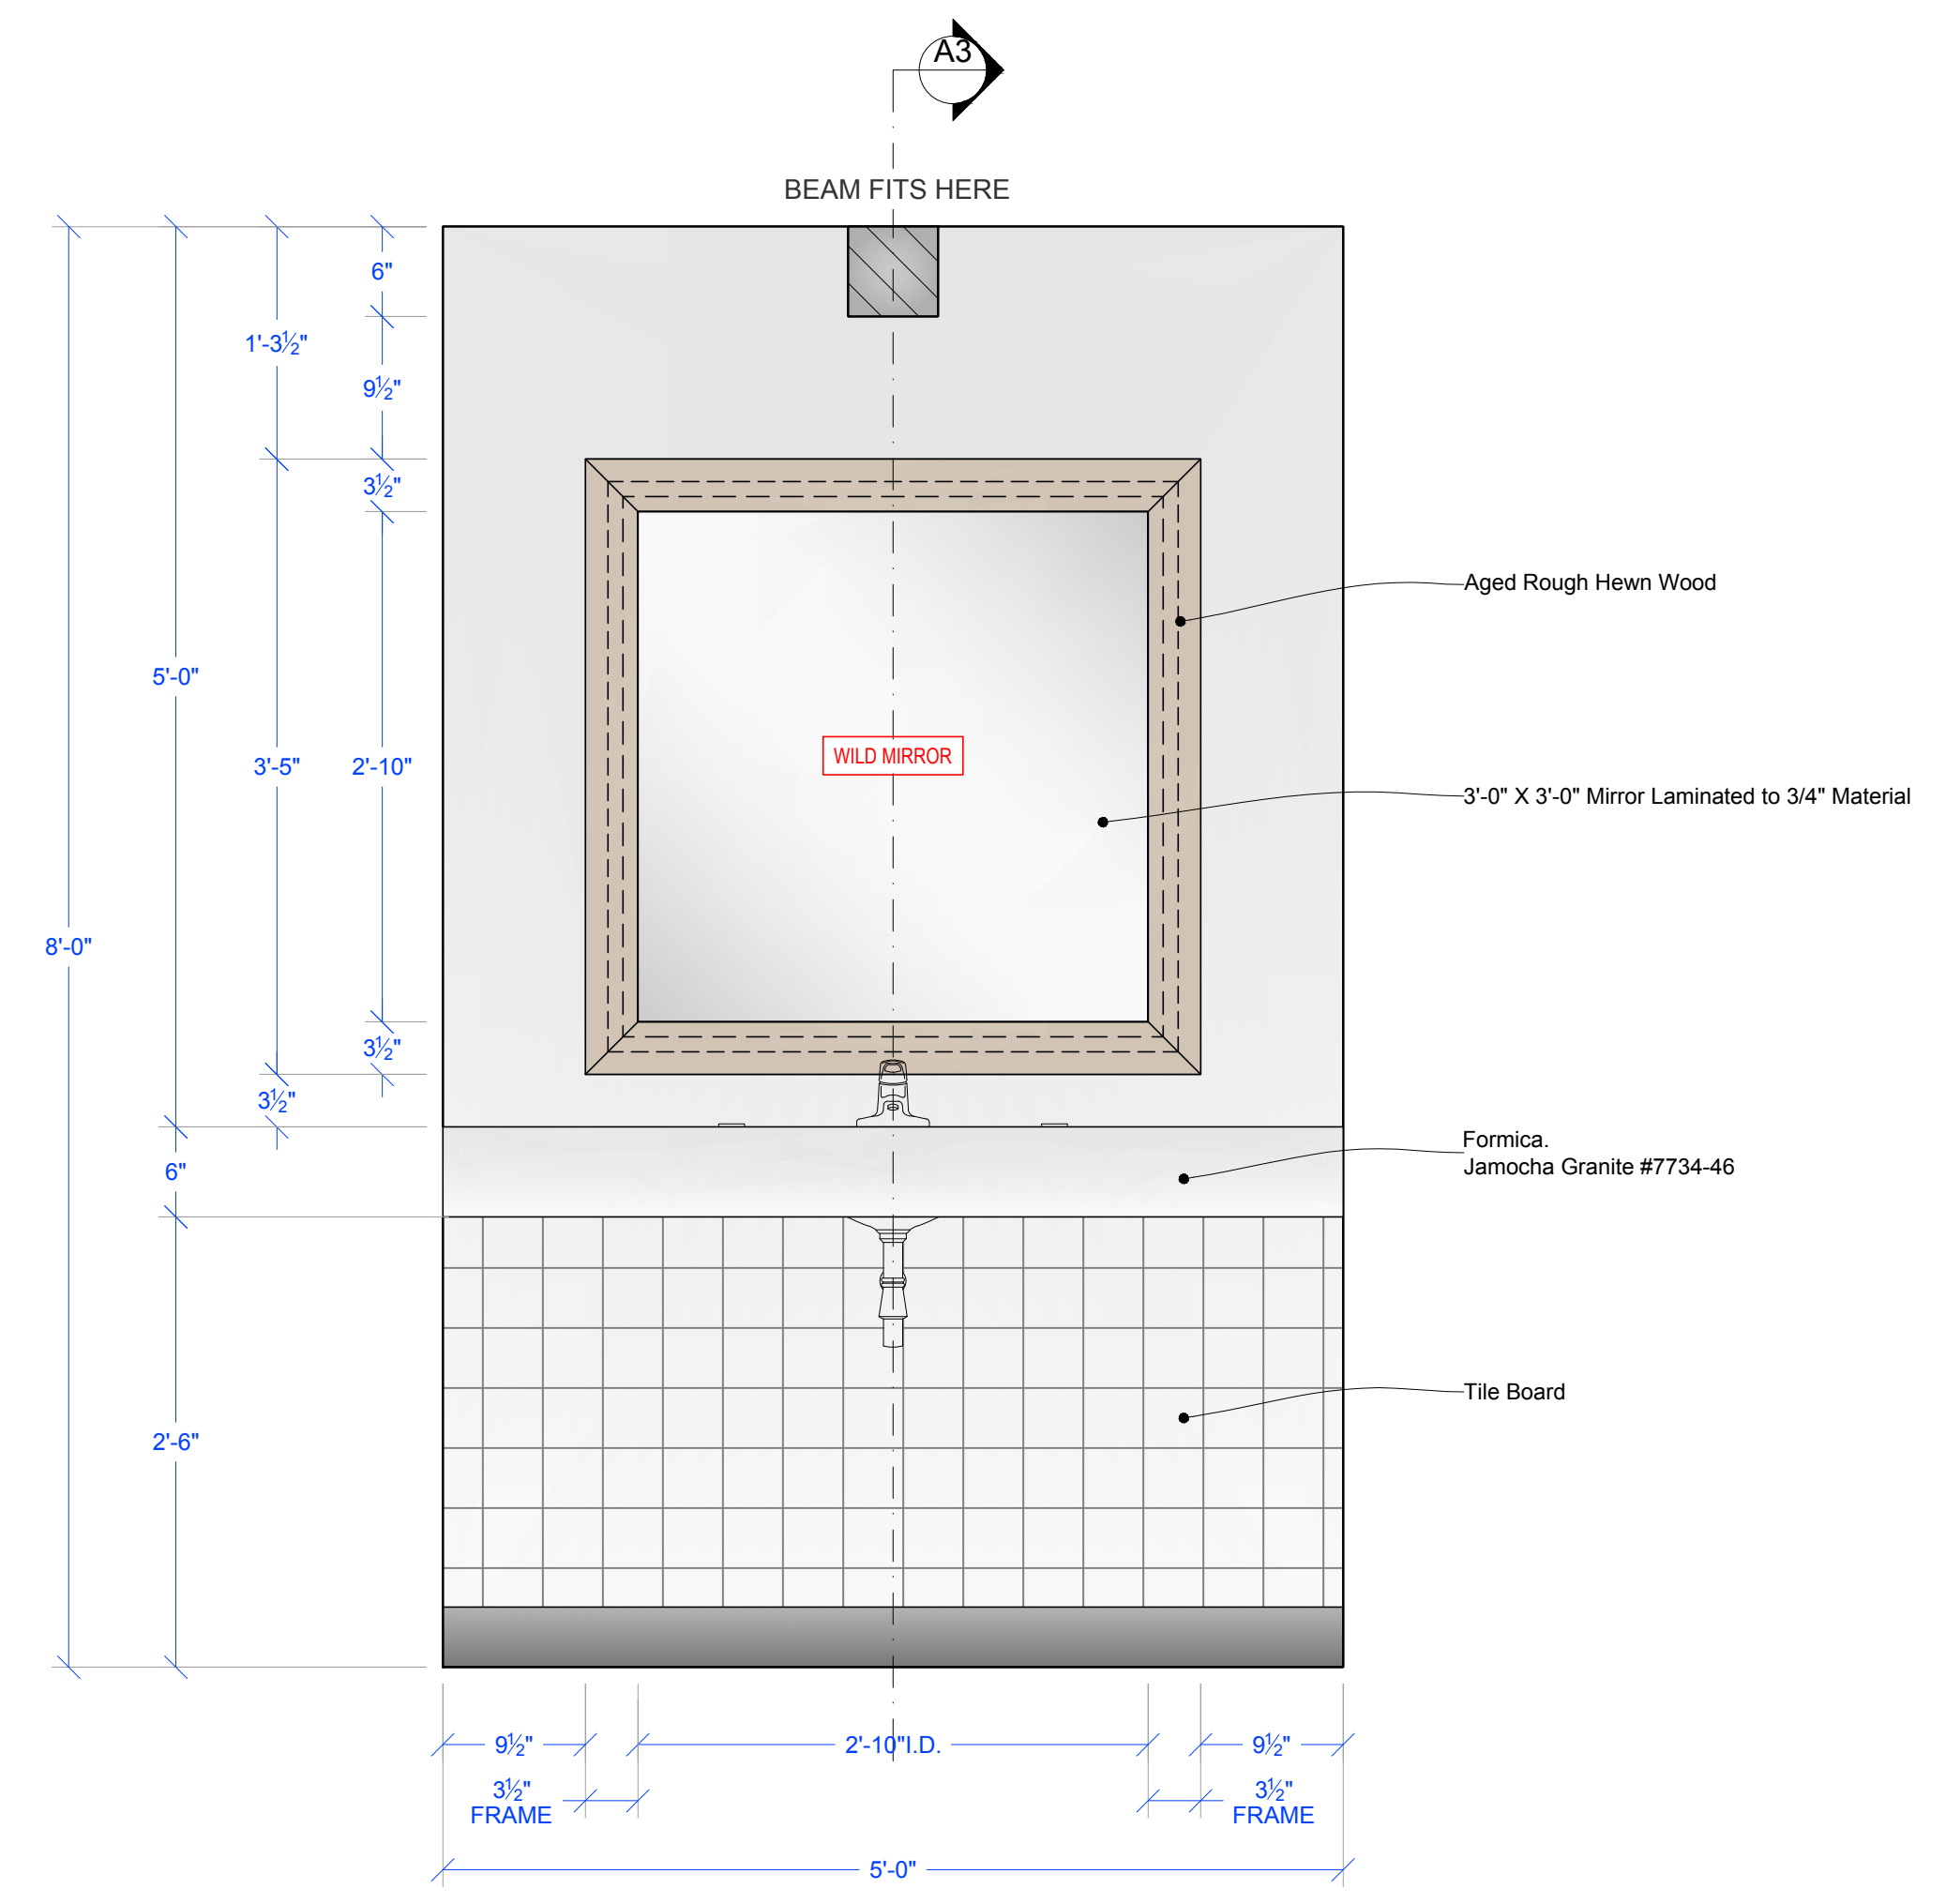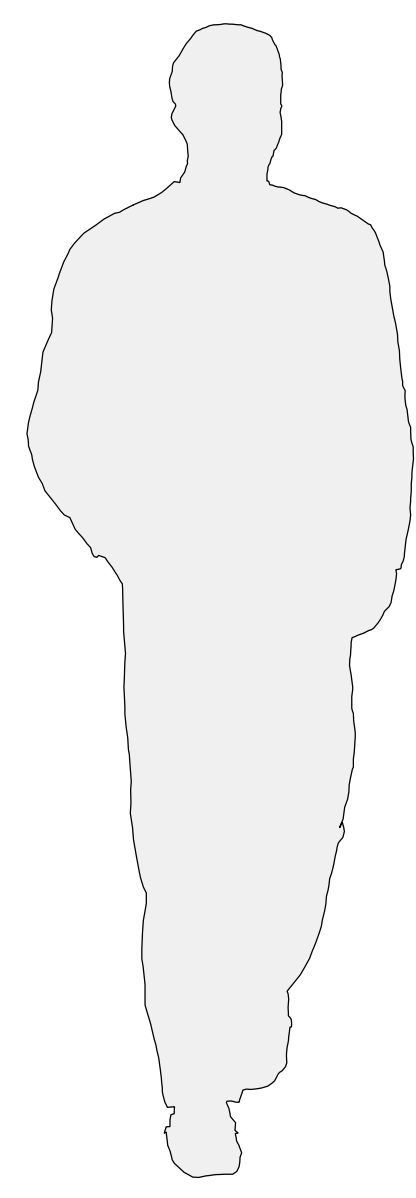


A ELEVATION
SCALE: 1" = 1'-0"

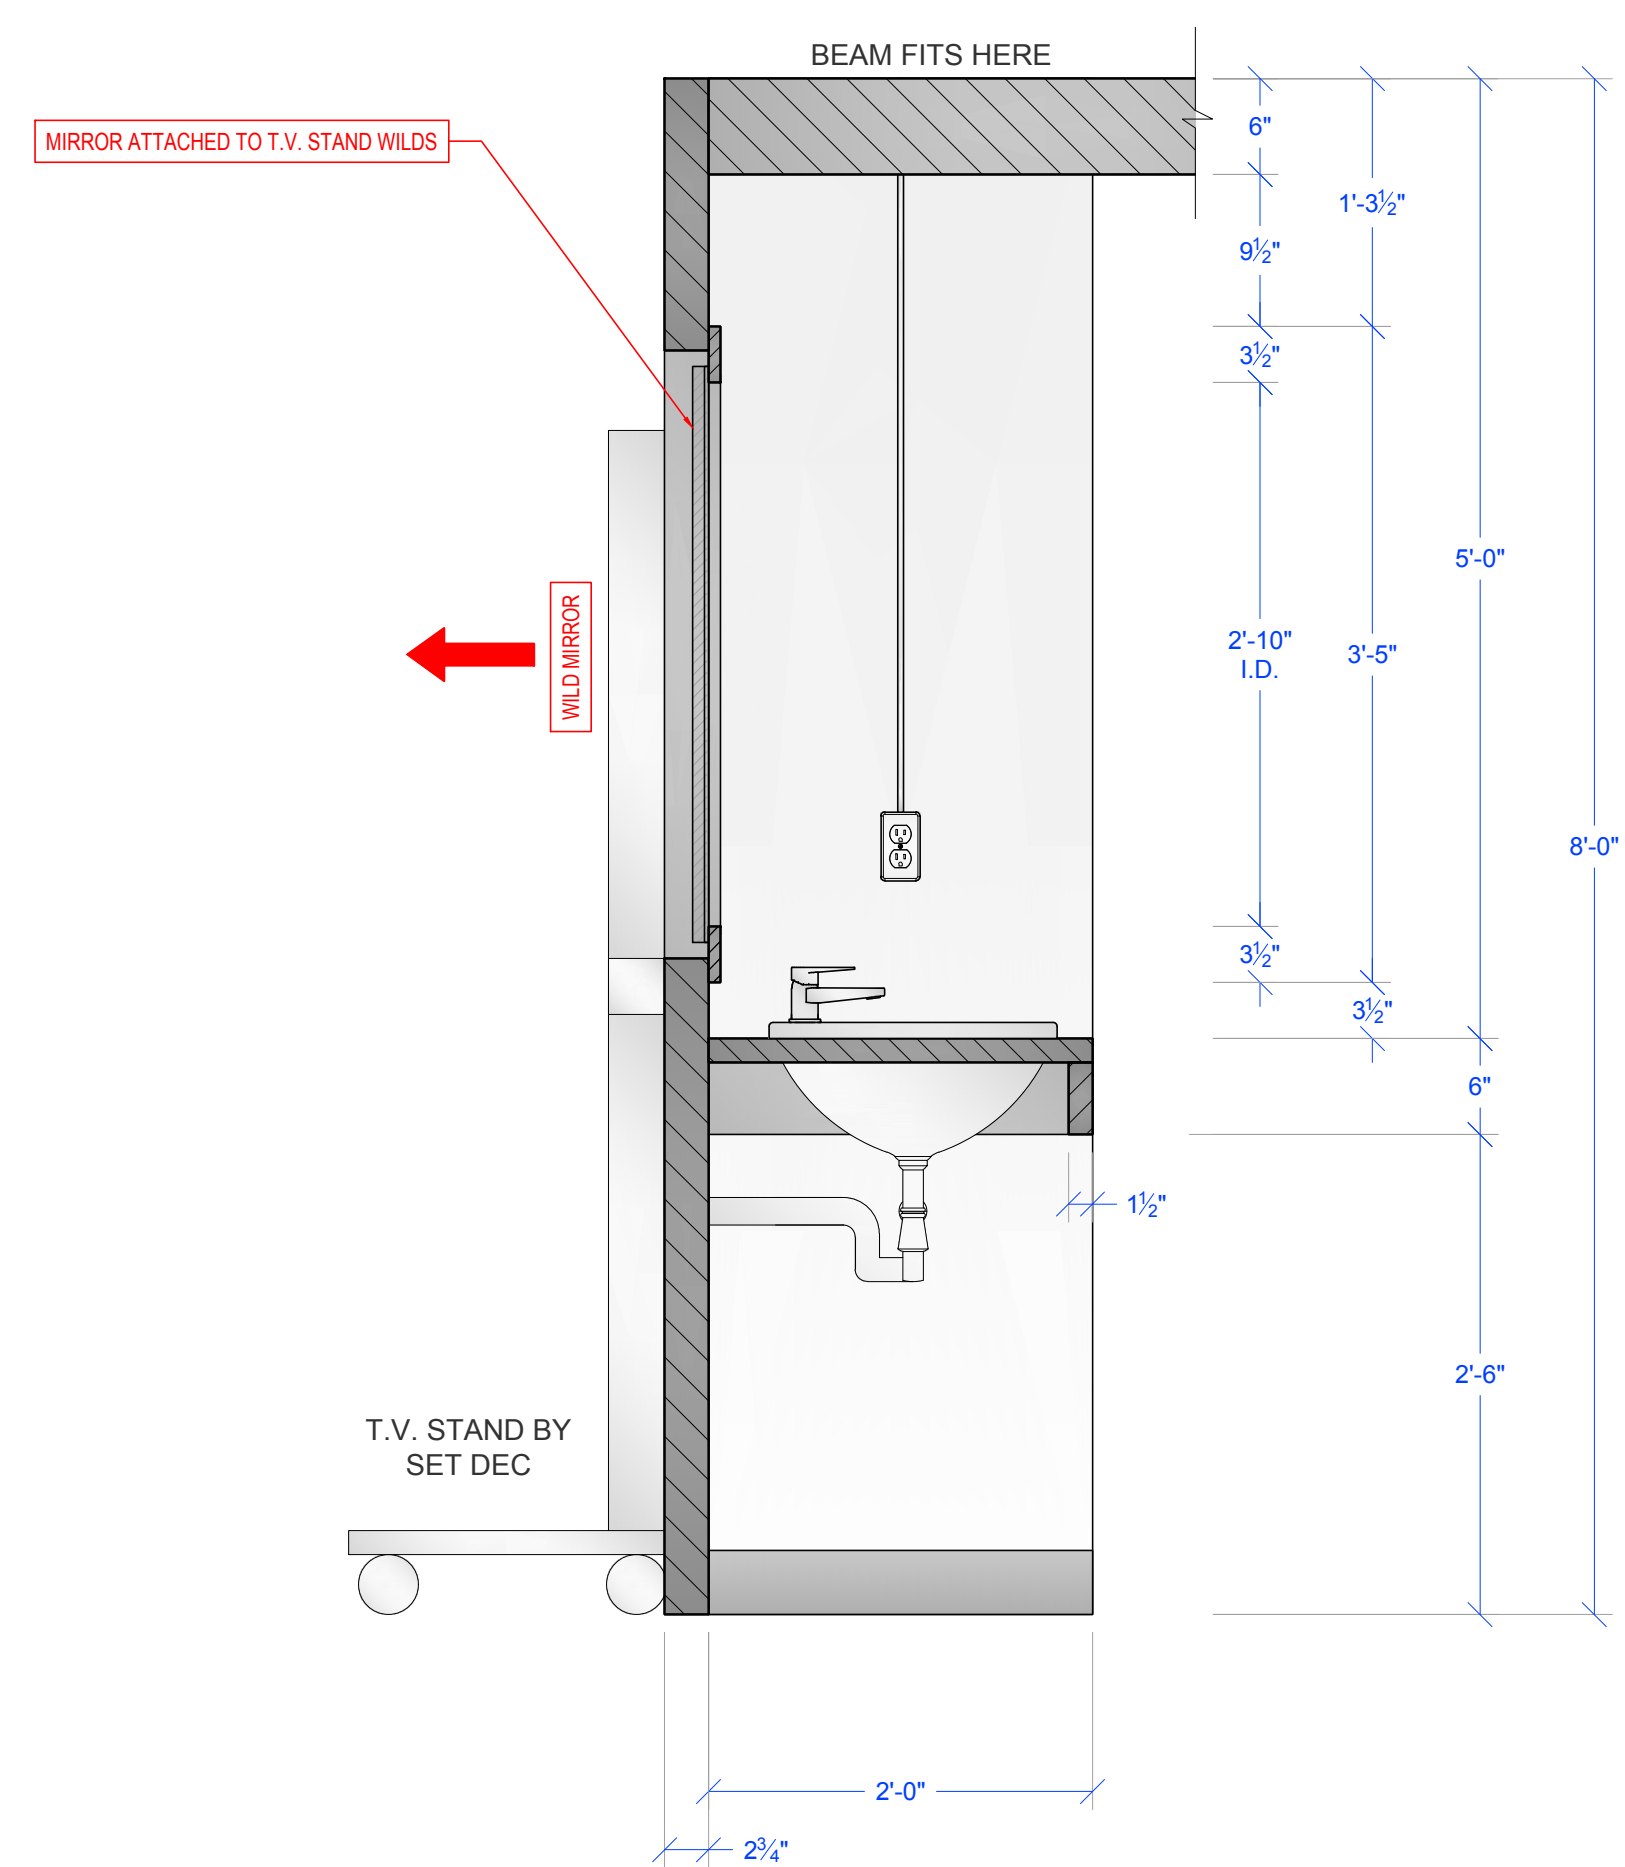

A3 SECTION
SCALE: 1" = 1'-0"

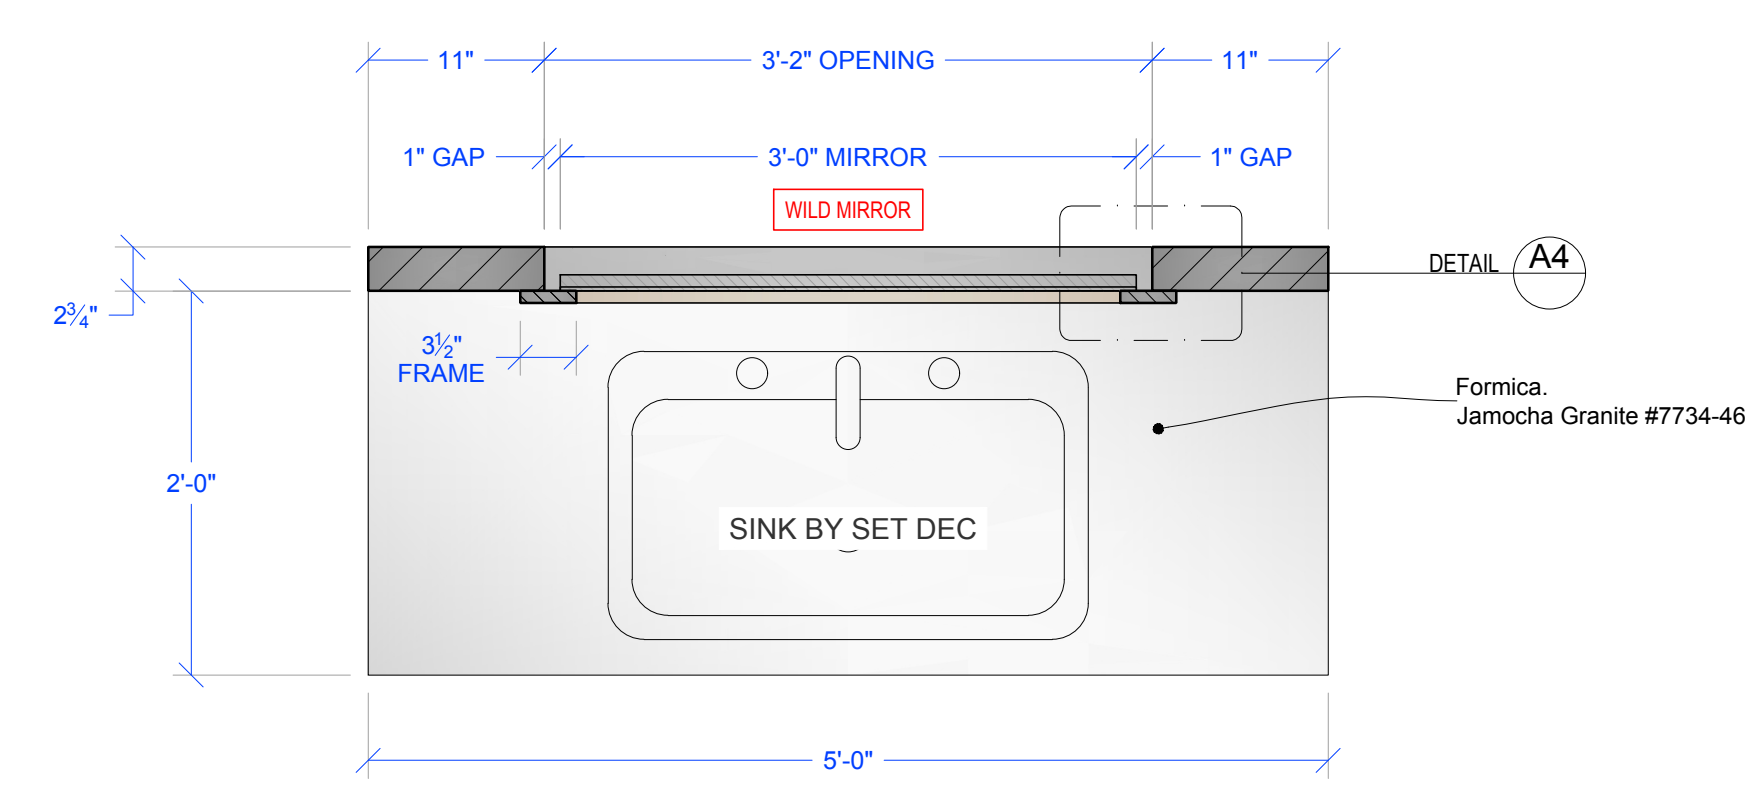

A2 PLAN
SCALE: 1" = 1'-0"

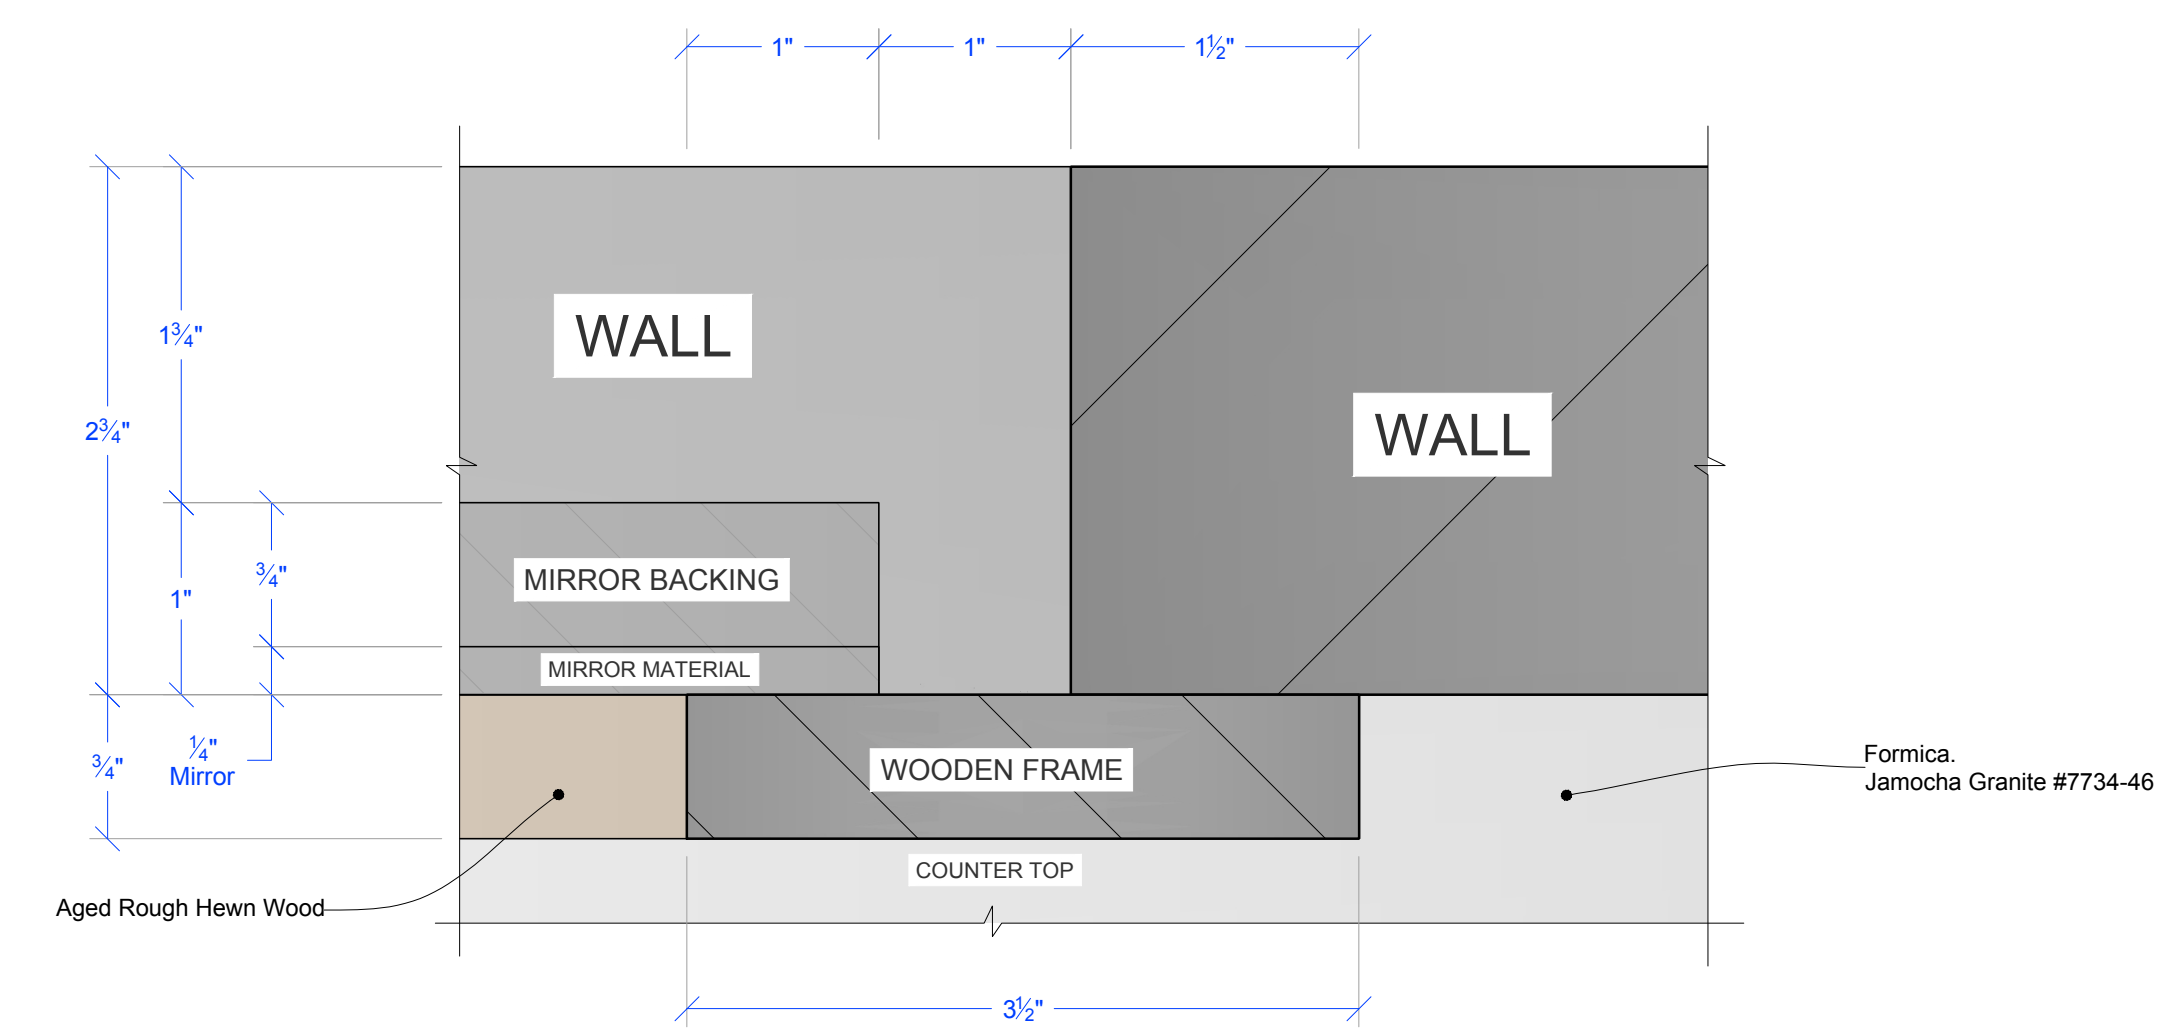

A4 DETAIL
SCALE: FULL SCALE

RELEASED
12-18-2024
SHOOT DATE: 01.09.25

